



These plans were not prepared by nor checked by a licensed architect and/or engineer.
E. F. P. does not represent or imply itself to be a licensed architect and/or licensed engineer.
Enjoy these plans but use them at your own risk.
Resale of these plans, in whole or part, is strictly prohibited.


Excellent Floor Plans
<https://sites.google.com/excellentfloorplans>
<https://www.ebay.com/str/excellentfloorplans>
<https://excellentfloorplans.etsy.com>

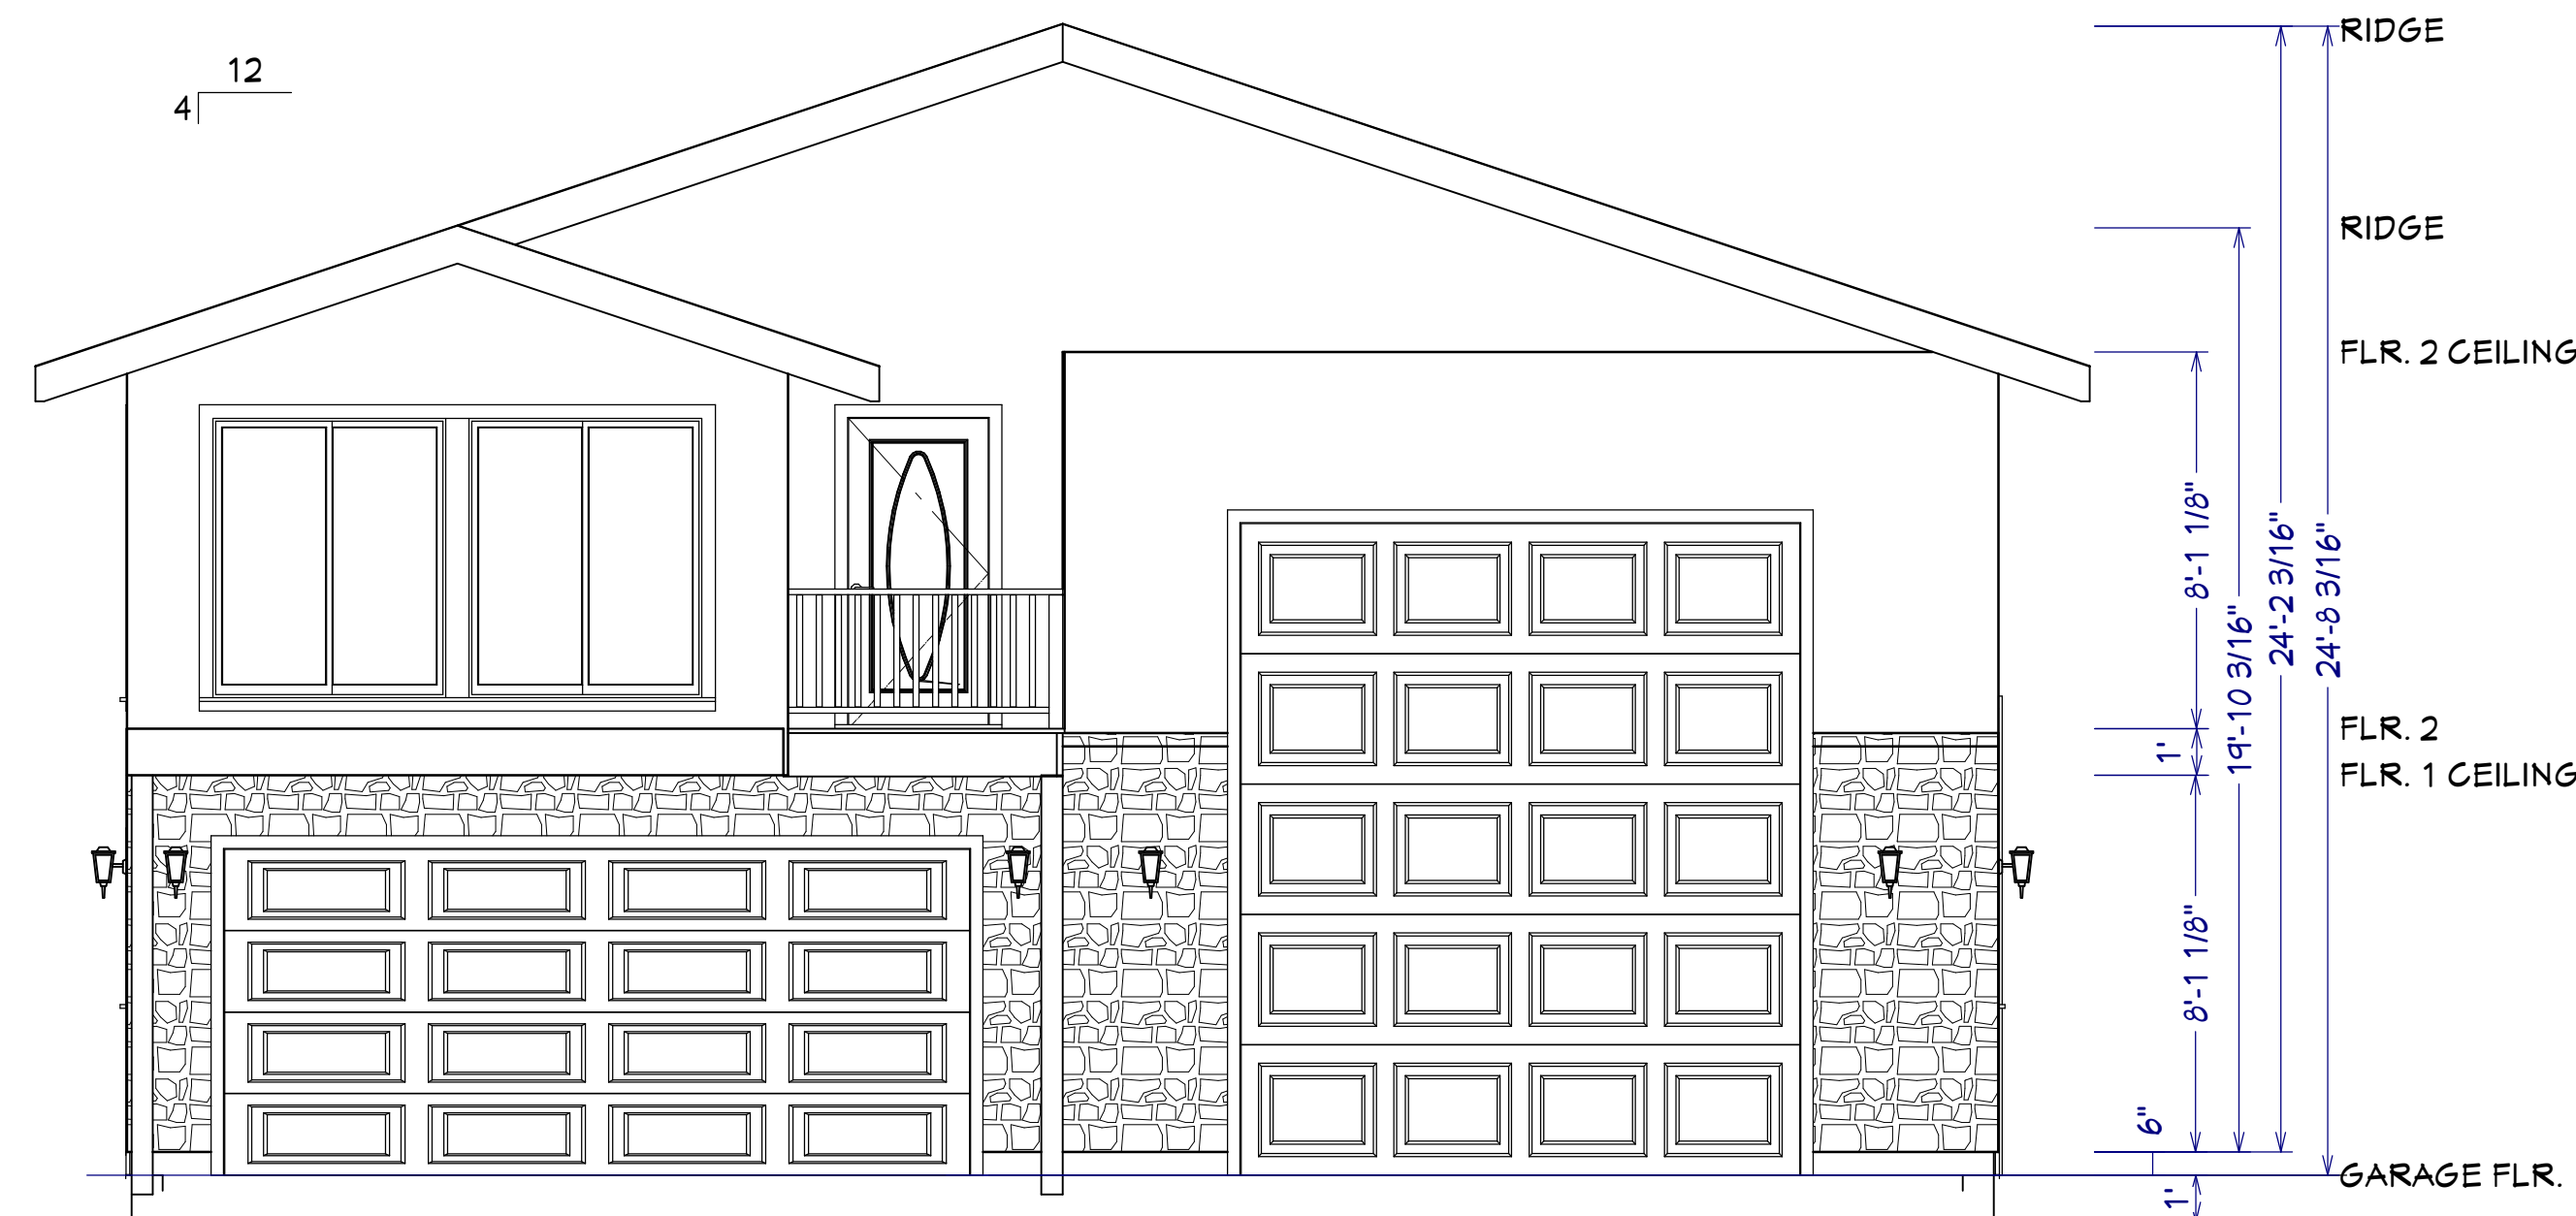


FRONT ELEVATION
SCALE: 1/4" = 1'

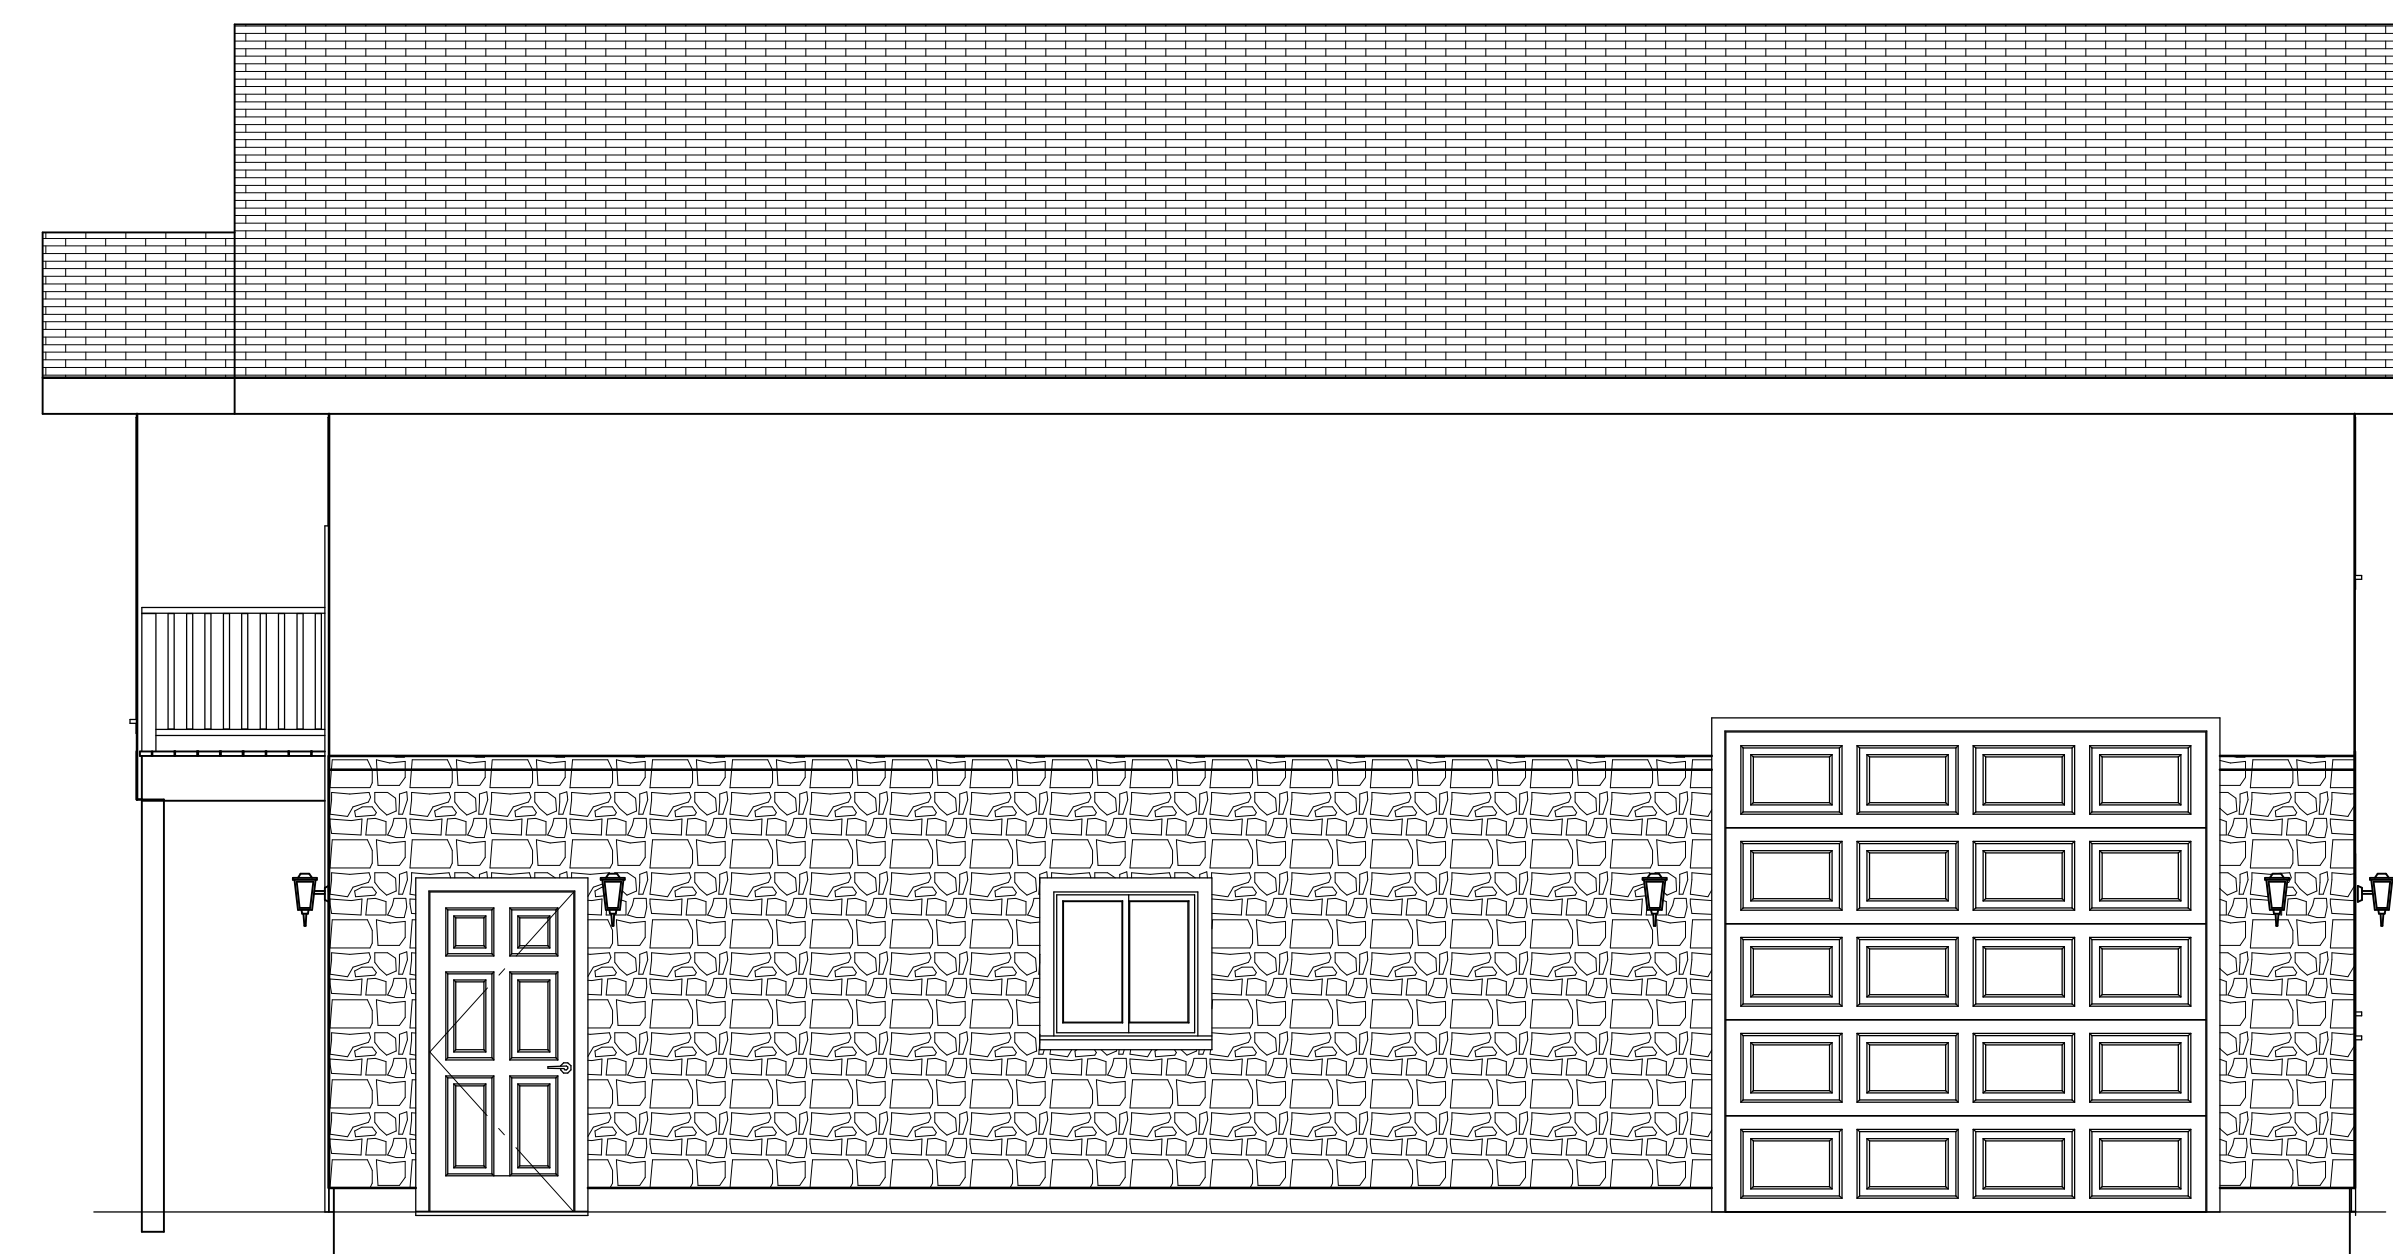

RIGHT ELEVATION
SCALE: 1/4" = 1'

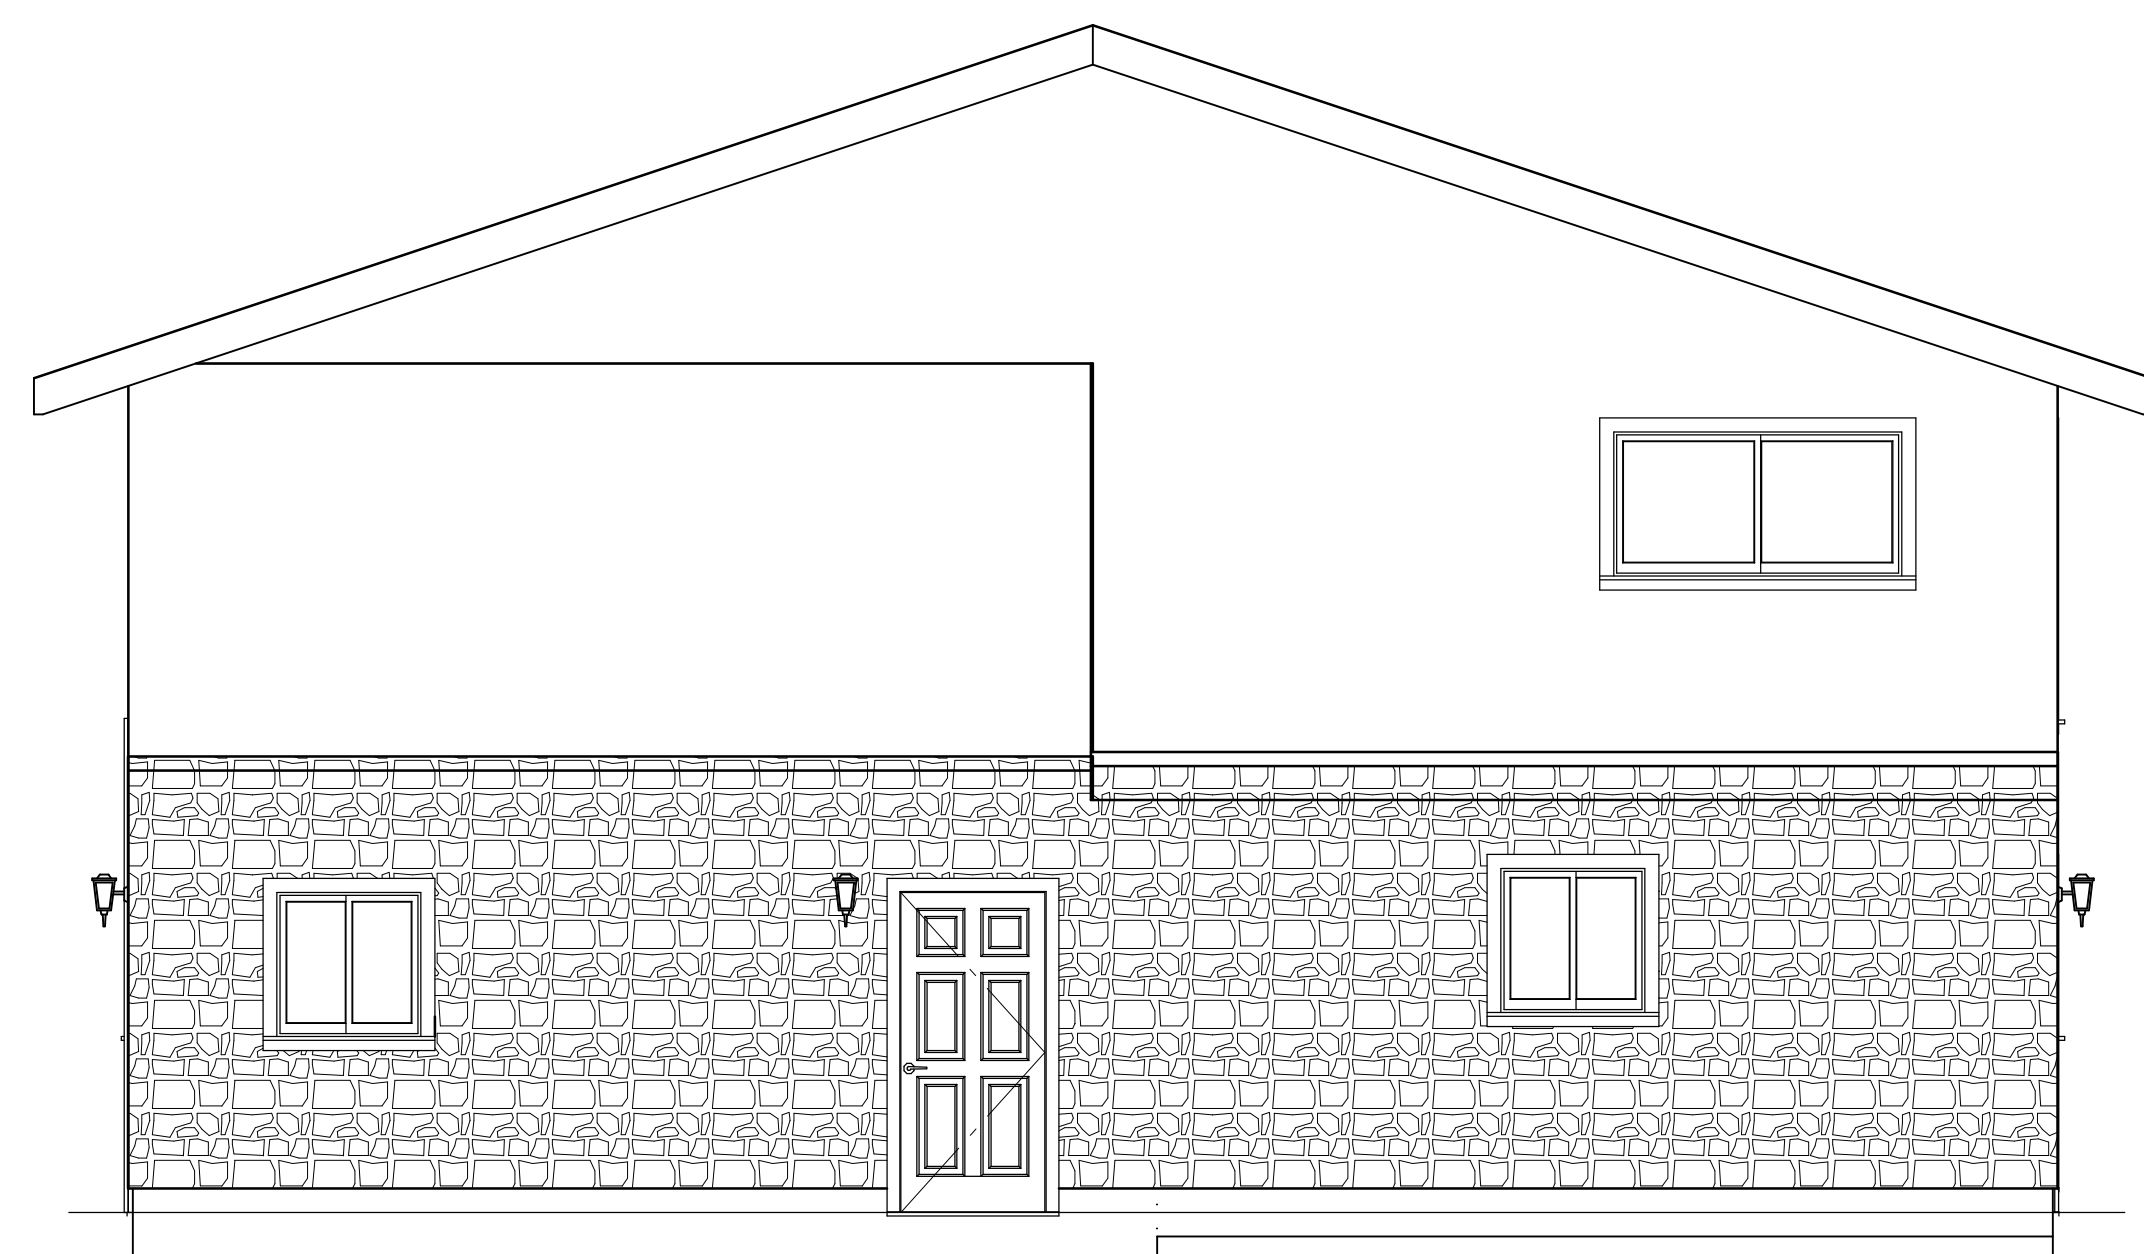

REAR ELEVATION
SCALE: 1/4" = 1'

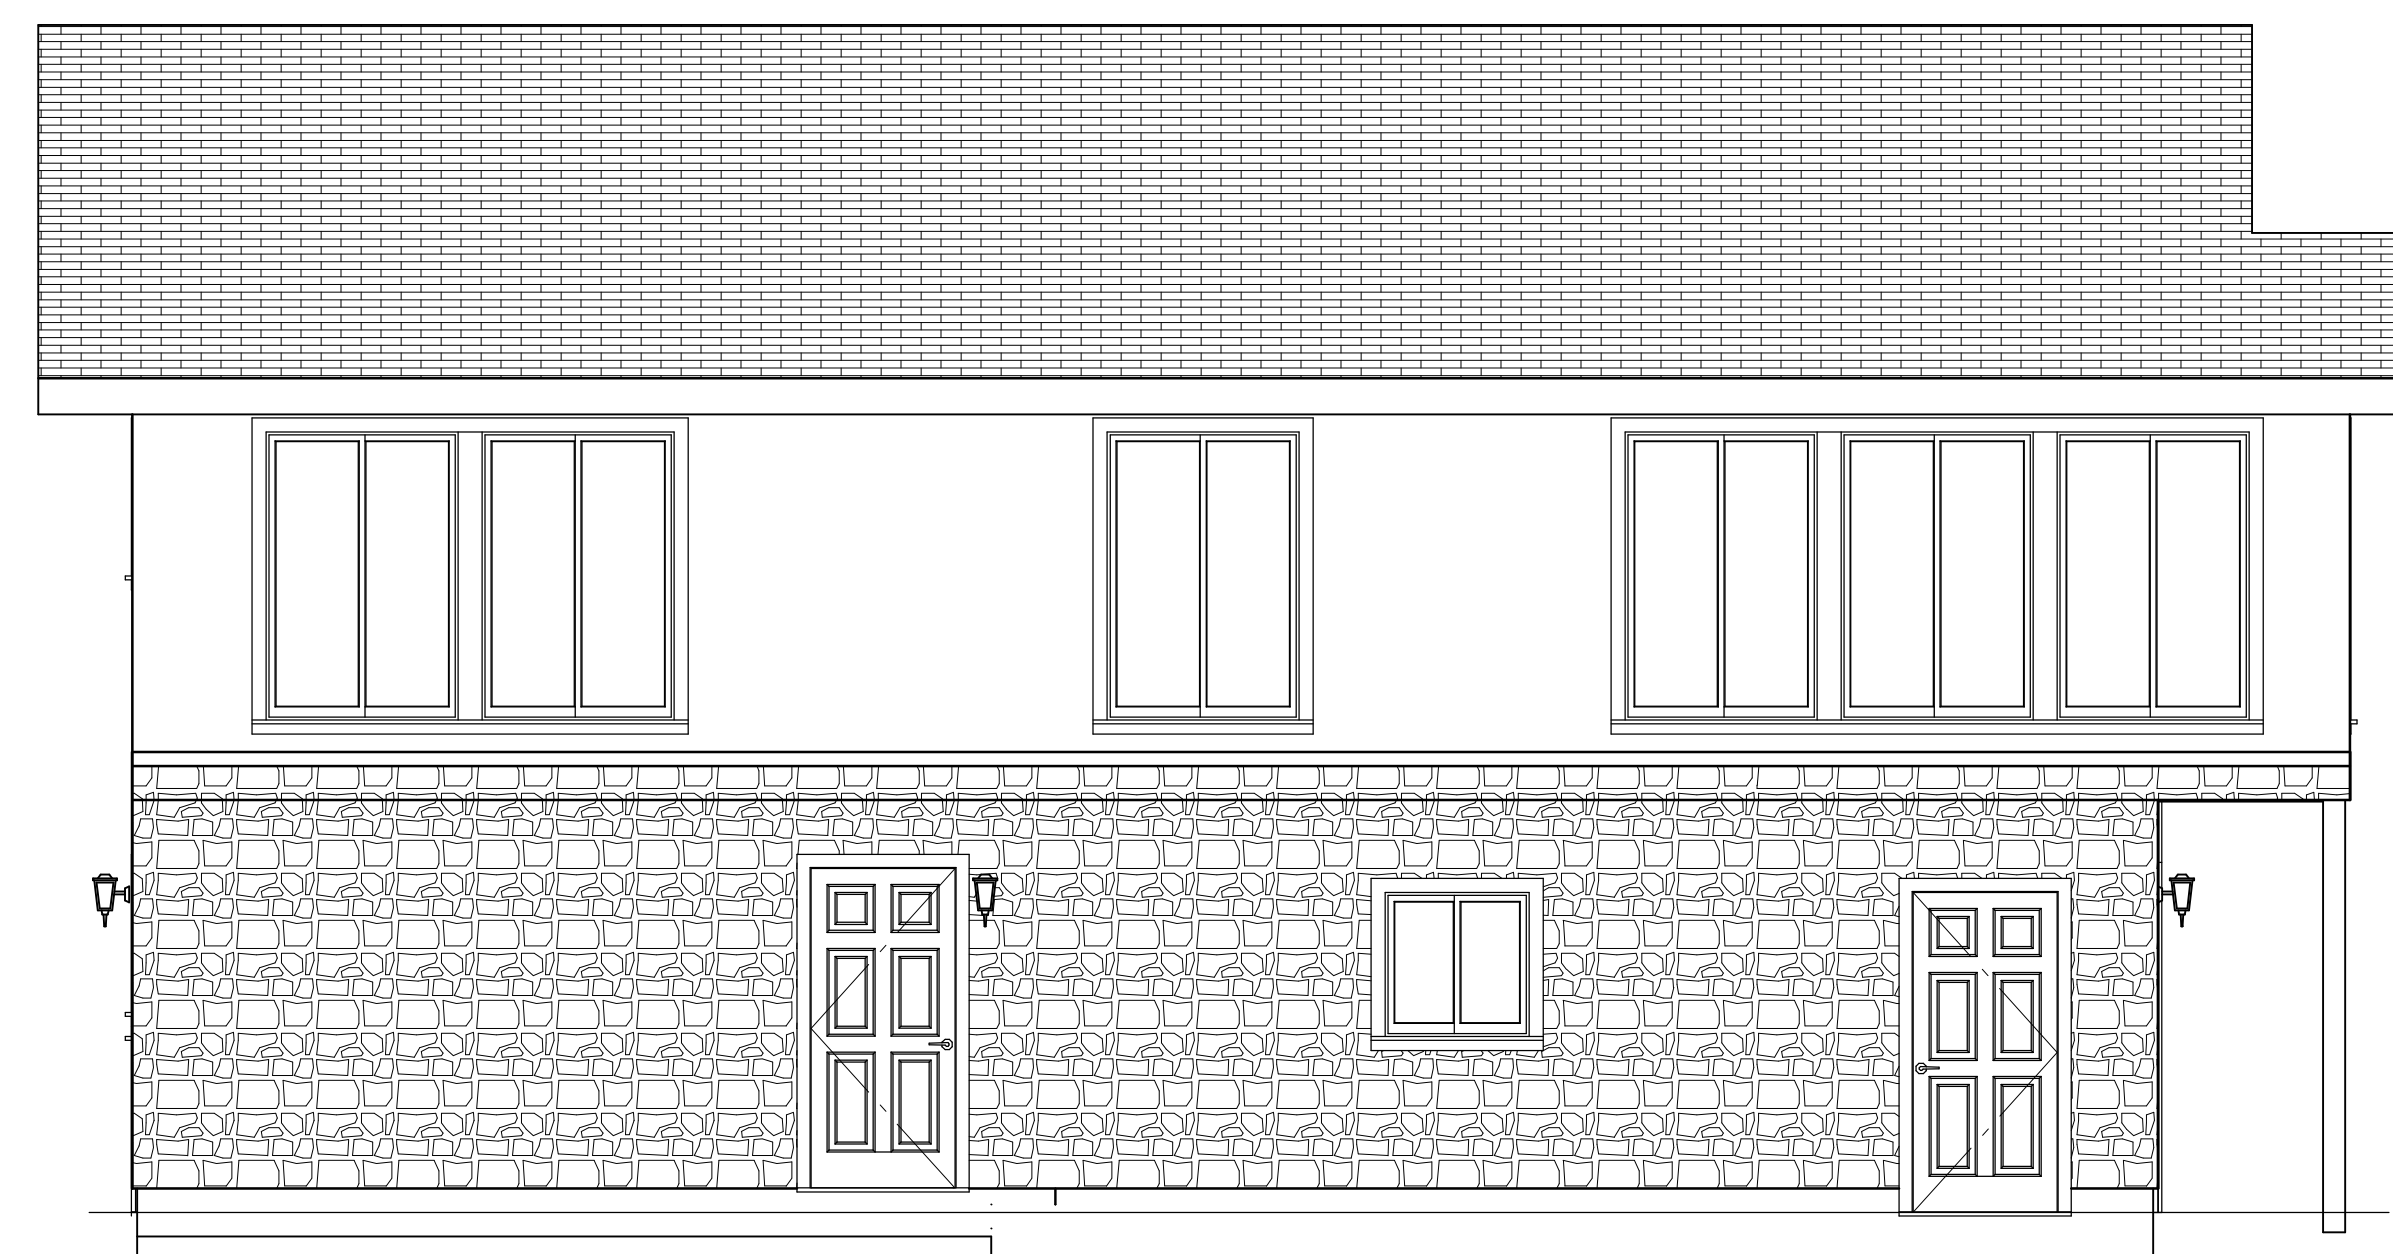

LEFT ELEVATION
SCALE: 1/4" = 1'


40x42 House #40X42H1C

SQUARE FEET: 1,153 (321 1st (w.c., shop, storage, entry), 832 2nd)
WIDTH: 40'
DEPTH: 46'
EXTERIOR WALL STRUCTURE: 2X6 STUDS

**BUILDING CONTRACTOR/HOME OWNER
TO REVIEW AND VERIFY ALL DIMENSIONS,
AND SPECS BEFORE CONSTRUCTION
BEGINS. BUILDING TO BE BUILT AS
PER LOCAL CODE REQUIREMENTS.**

To the best of my knowledge these plans are drawn to comply with owner's and/ or builder's specifications and any changes made on them after prints are made will be done at the owner's and / or builder's expense and responsibility. The contractor shall verify all dimensions and enclosed drawing. E.F.P. is not liable for errors. While every effort has been made in the preparation of this plan to avoid mistakes, the maker cannot guarantee against human error. The contractor of the job must check all dimensions and other details prior to construction and be solely responsible thereafter. All calculations and member sizing should be verified for your building by a certified building official.




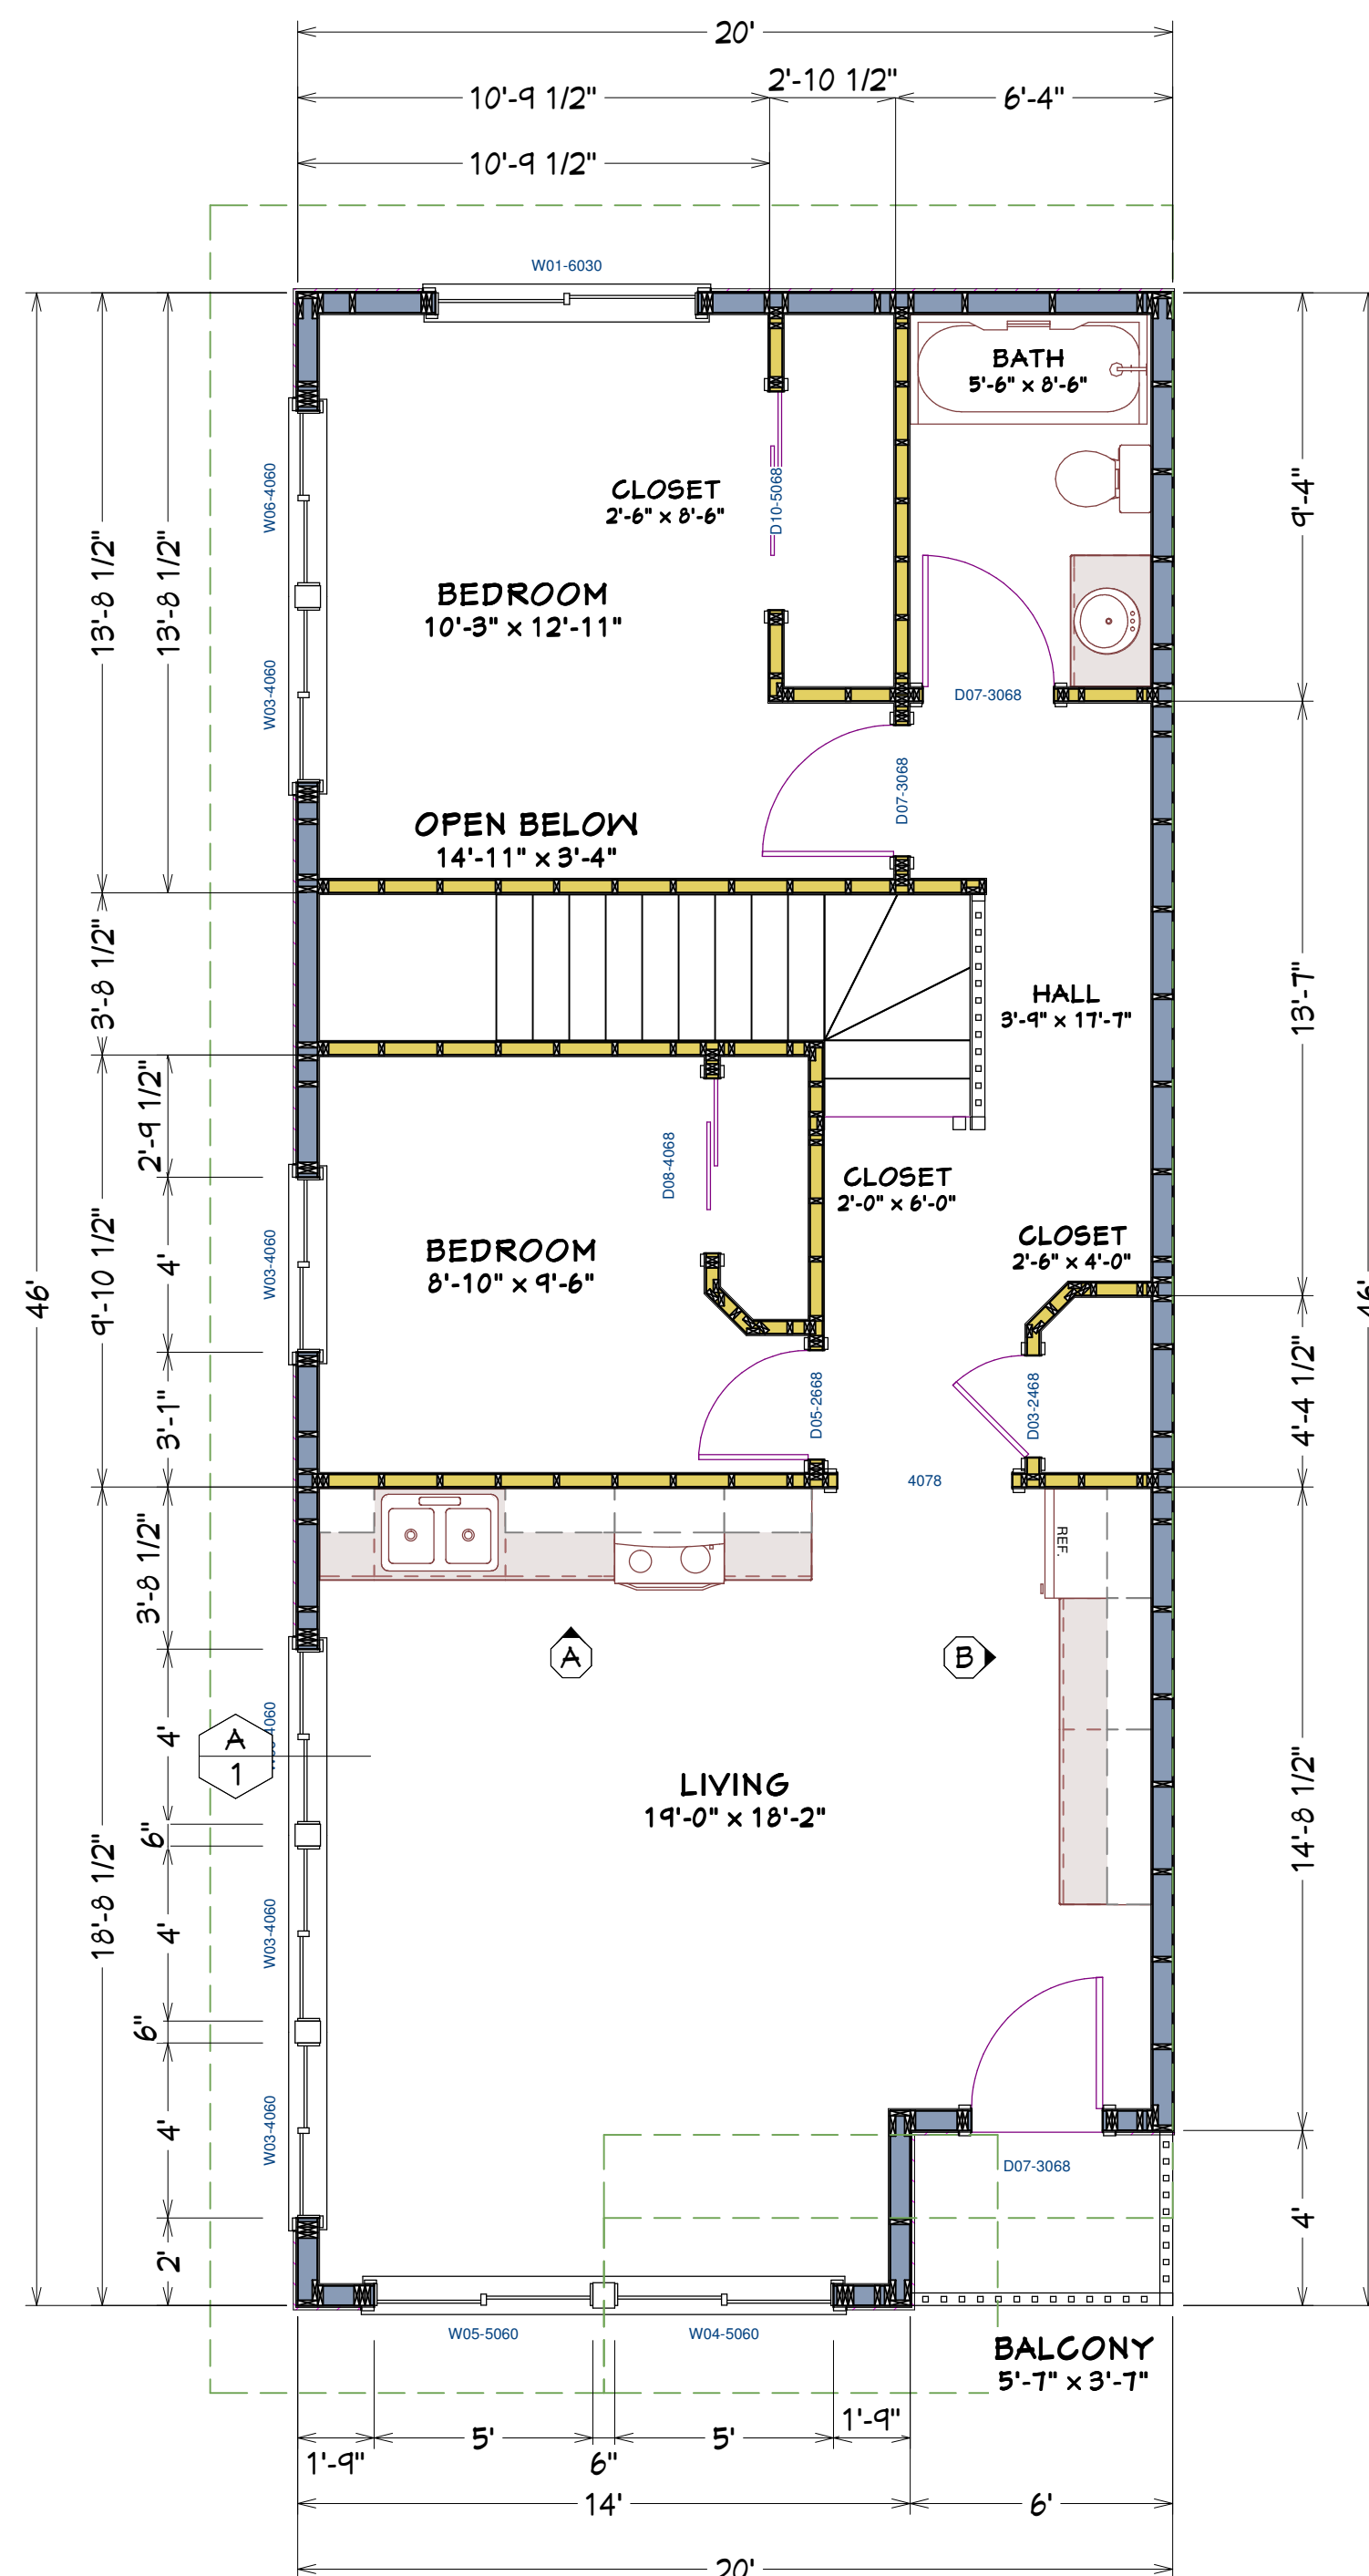


2ND FLOOR PLAN
SCALE: 1/4" = 1'

DOOR SCHEDULE					
NUMBER	LABEL	QTY	FLOOR	SIZE	COMMENTS
D01	D01-120140	1	1	120140	
D02	D02-16070	1	1	16070	
D03	D03-2468	1	2	2468	
D04	D04-3068	6	1	3068	
D05	D05-2668	1	2	2668	
D06	D06-2668	2	1	2668	
D07	D07-3068	3	2	3068	
D08	D08-4068	1	2	4068	
D09	D09-5068	1	1	5068	
D10	D10-5068	1	2	5068	
D11	D11-100100	1	1	100100	


WINDOW SCHEDULE					
NUMBER	LABEL	QTY	FLOOR	SIZE	DESCRIPTION
W01	W01-6030	1	2	6030	LEFT SLIDING
W02	W02-3030	2	1	3030	RIGHT SLIDING
W03	W03-4060	4	2	4060	RIGHT SLIDING
W04	W04-5060	1	2	5060	RIGHT SLIDING
W05	W05-5060	1	2	5060	LEFT SLIDING
W06	W06-4060	2	2	4060	LEFT SLIDING
W07	W07-3030	2	1	3030	LEFT SLIDING

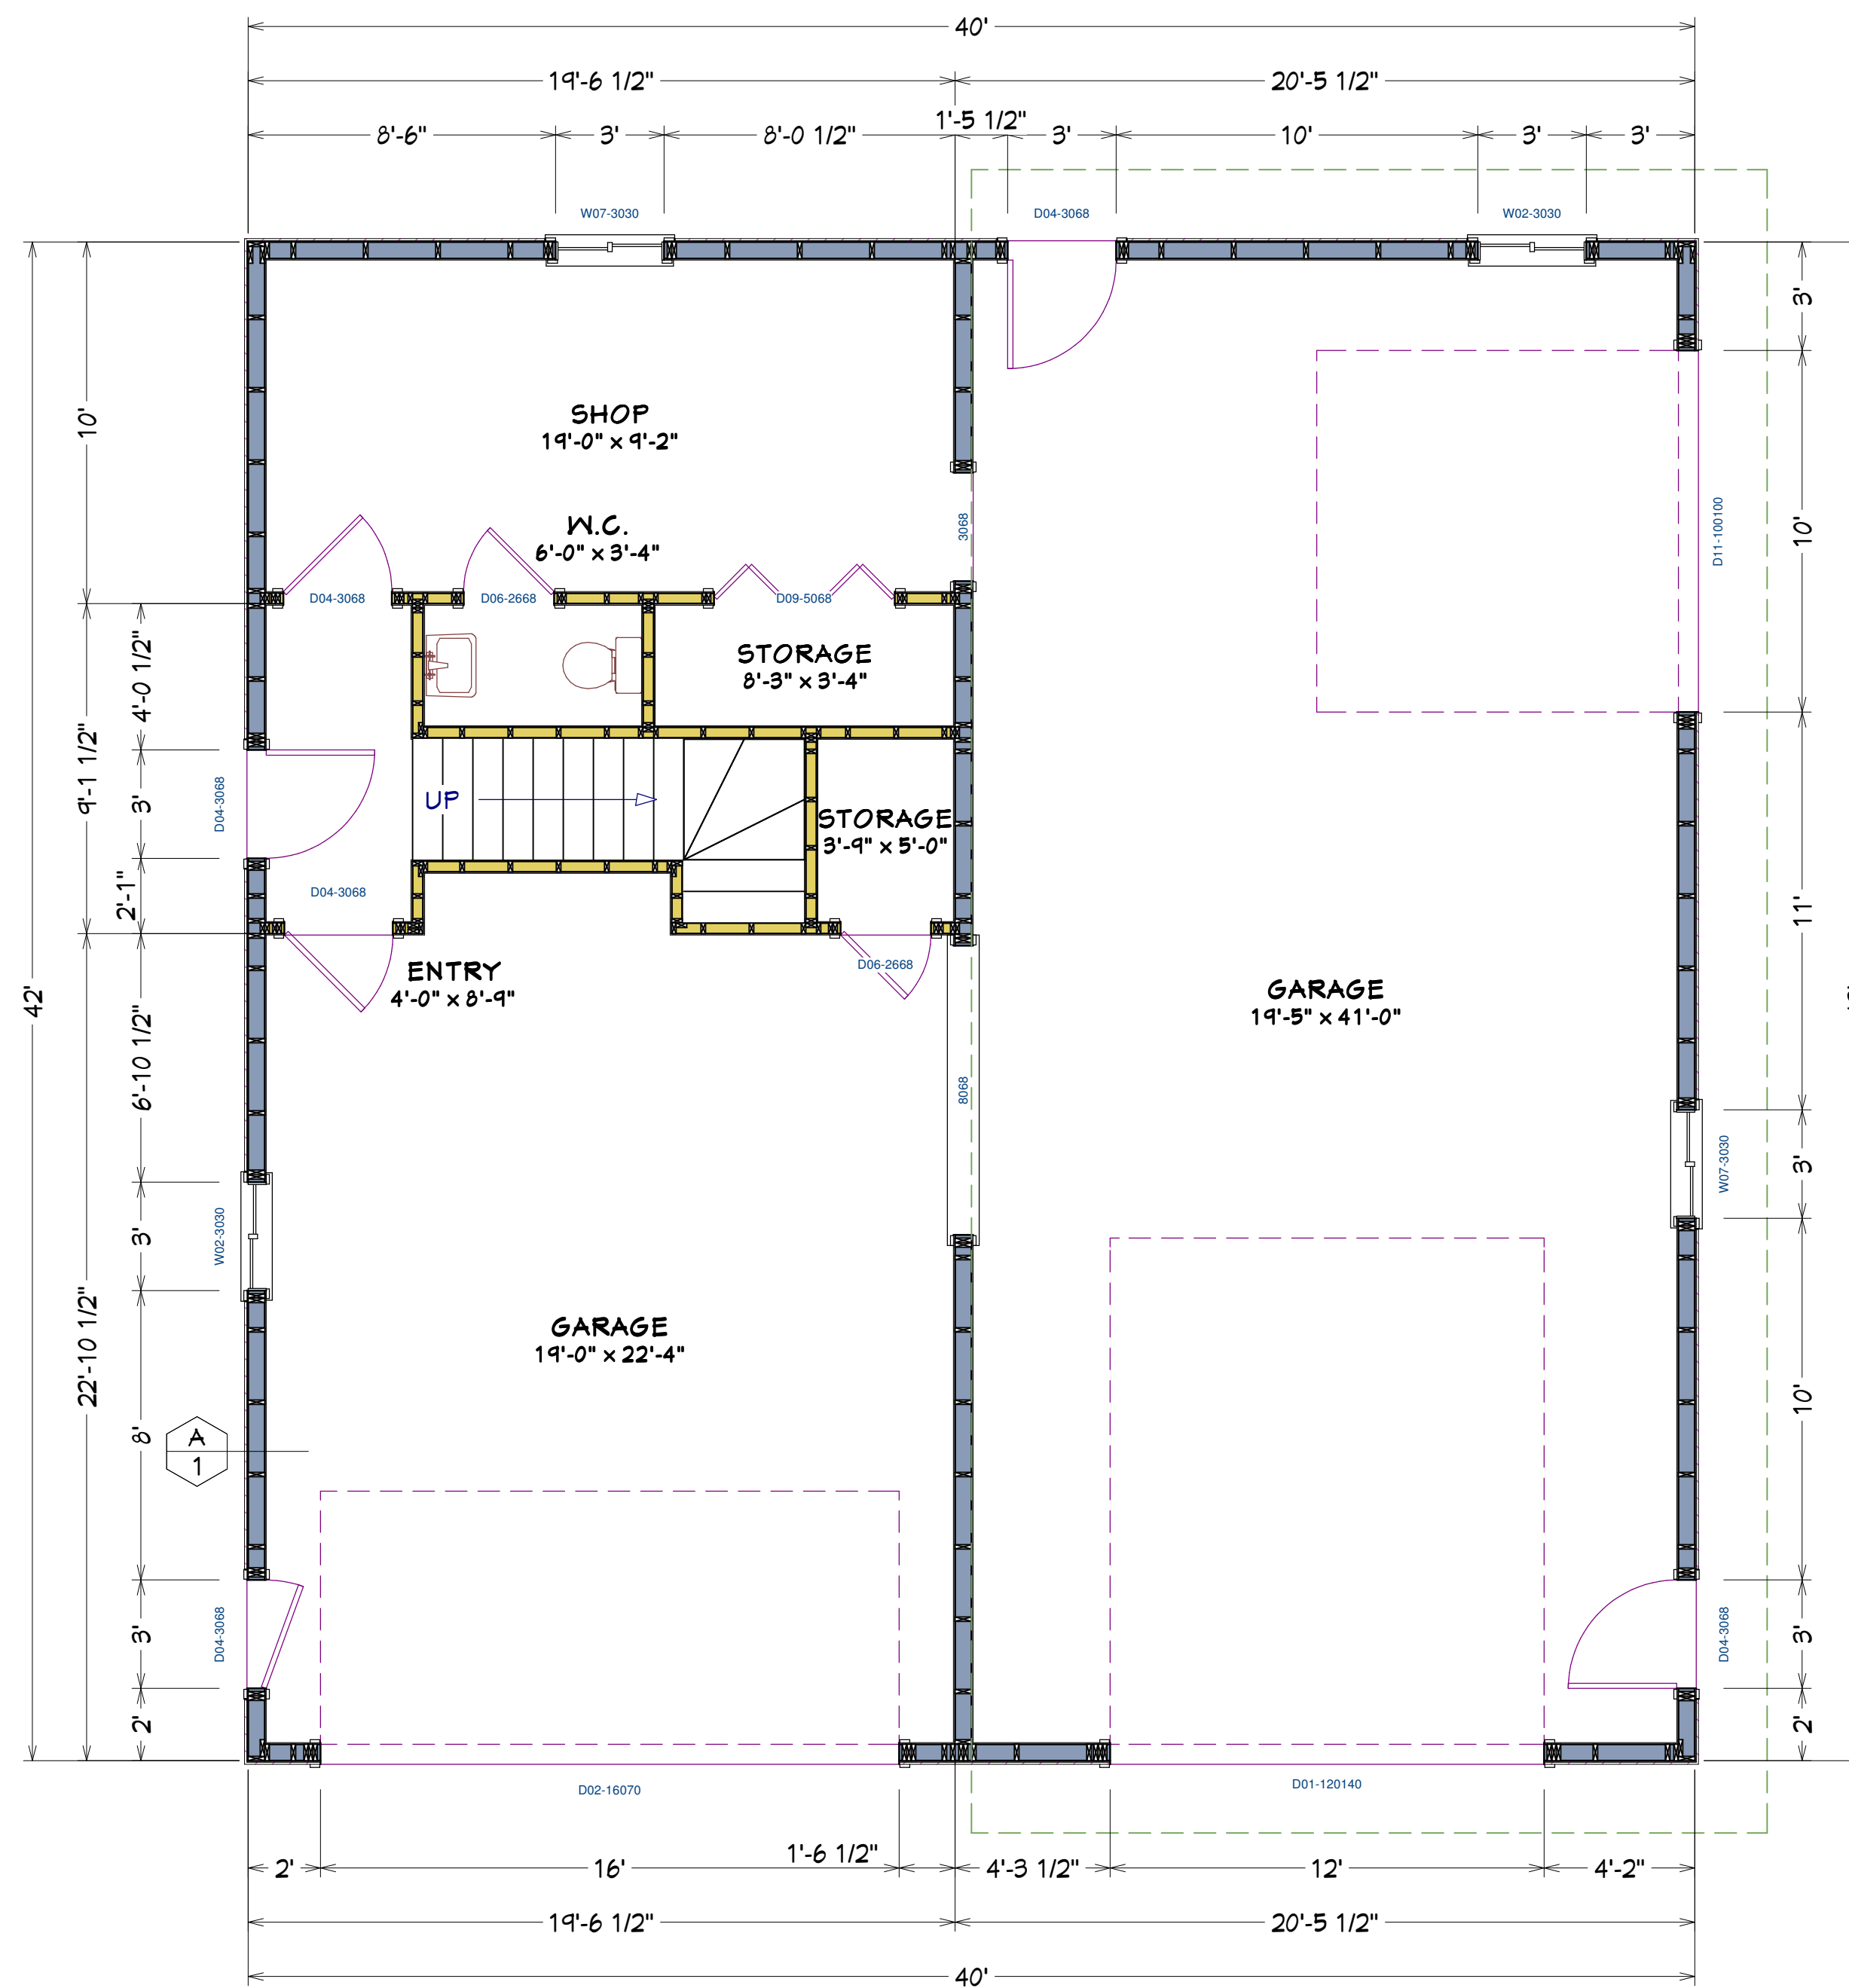


MAIN FLOOR PLAN
SCALE: 1/4" = 1'

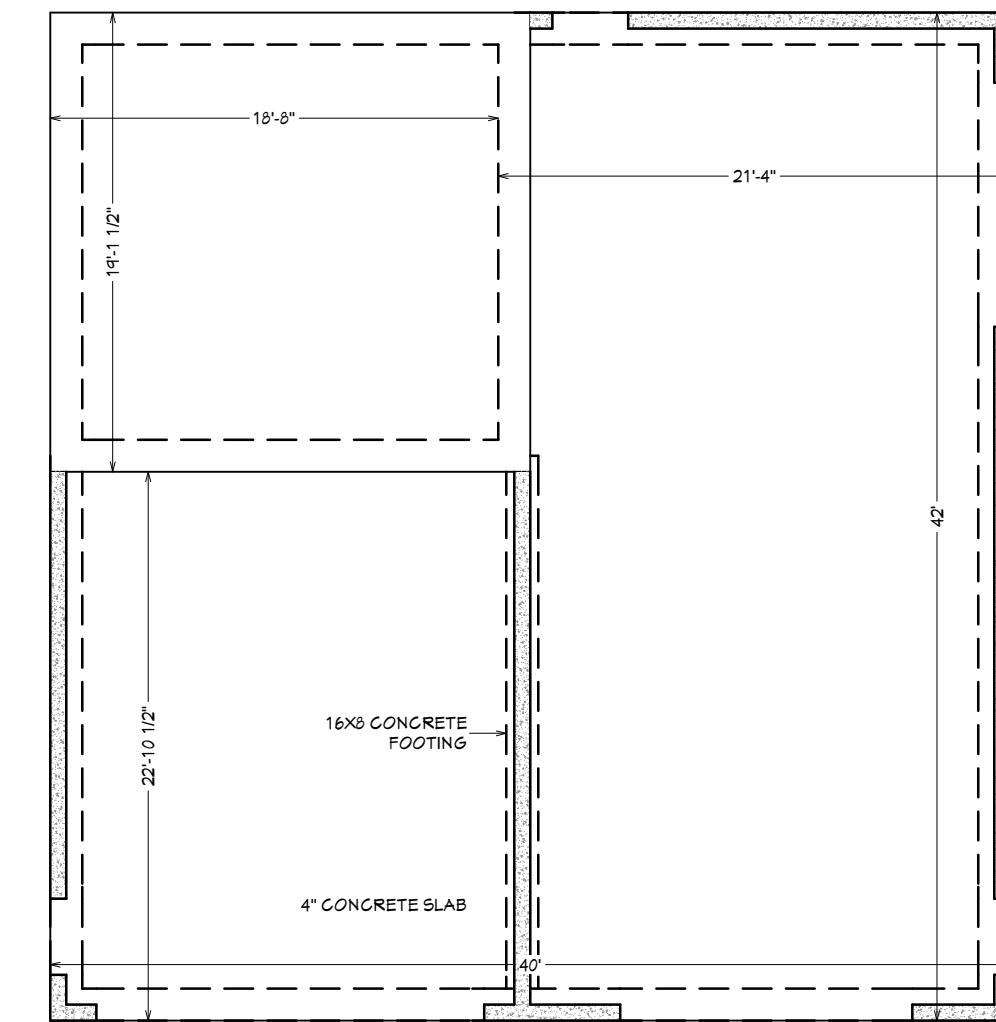

FOUNDATION PLAN
SCALE: 1/8" = 1'

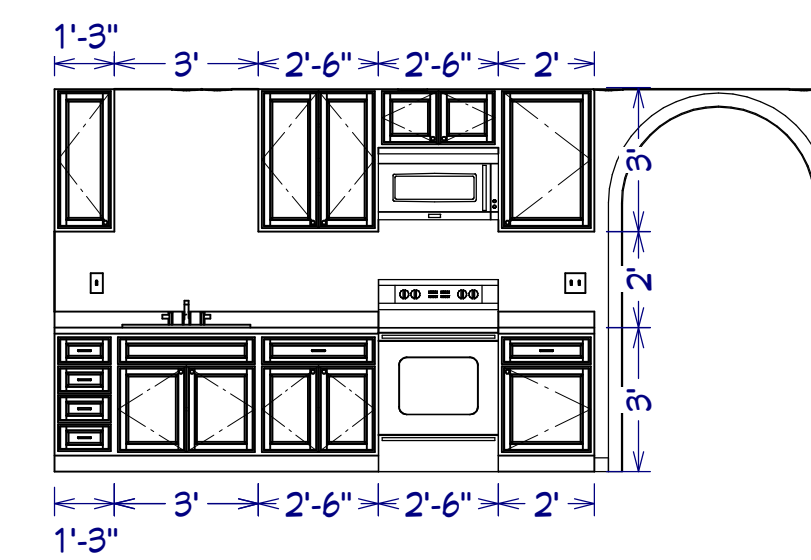

CABINET ELEVATION A
SCALE: 1/4" = 1'

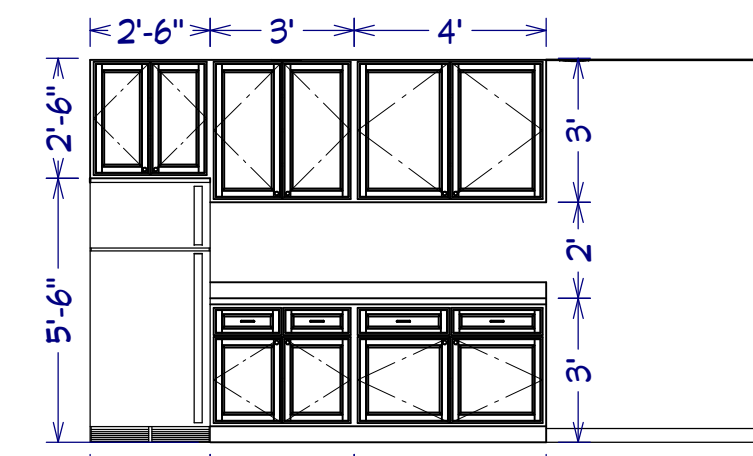


CABINET ELEVATION B
SCALE: 1/4" = 1'

40x42 House
#40X42H1C


These plans were not prepared by nor checked by a licensed architect and/or engineer.
E. F. P. does not represent or imply itself to be a licensed architect and/or licensed engineer.
Enjoy these plans but use them at your own risk.
Resale of these plans, in whole or part, is strictly prohibited.

Excellent Floor Plans
<https://sites.google.com/excellentfloorplans>
<https://www.ebay.com/str/excellentfloorplans>
<https://excellentfloorplans.etsy.com>


These plans were not prepared by nor checked by a licensed architect and/or engineer.
E.F.P. does not represent or imply itself to be a licensed architect and/or licensed engineer.
Enjoy these plans but use them at your own risk.
Resale of these plans, in whole or part, is strictly prohibited.

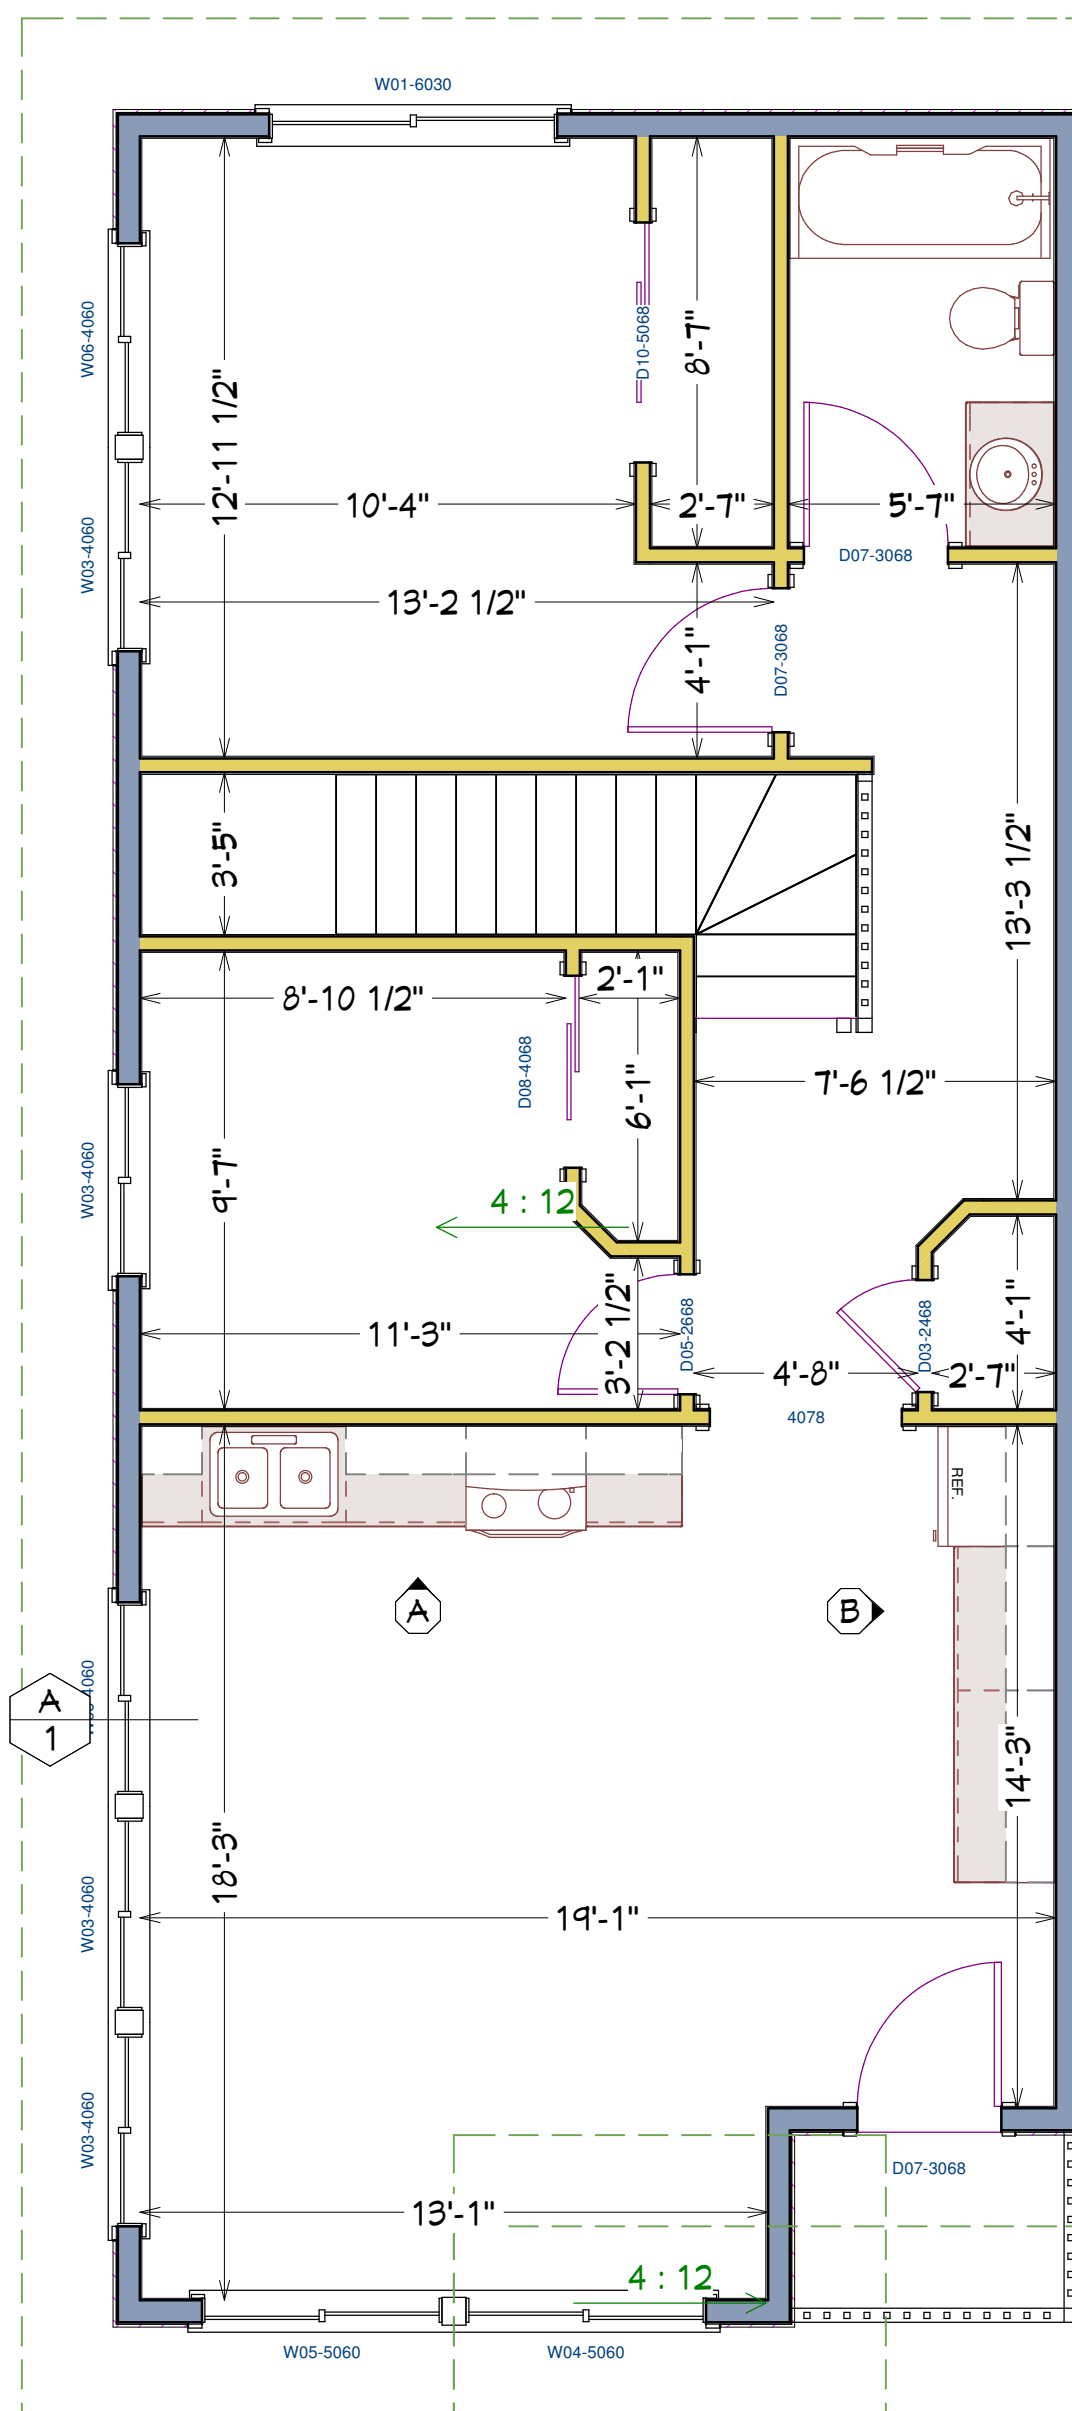

2ND FLOOR PLAN
SCALE: 1/4" = 1'

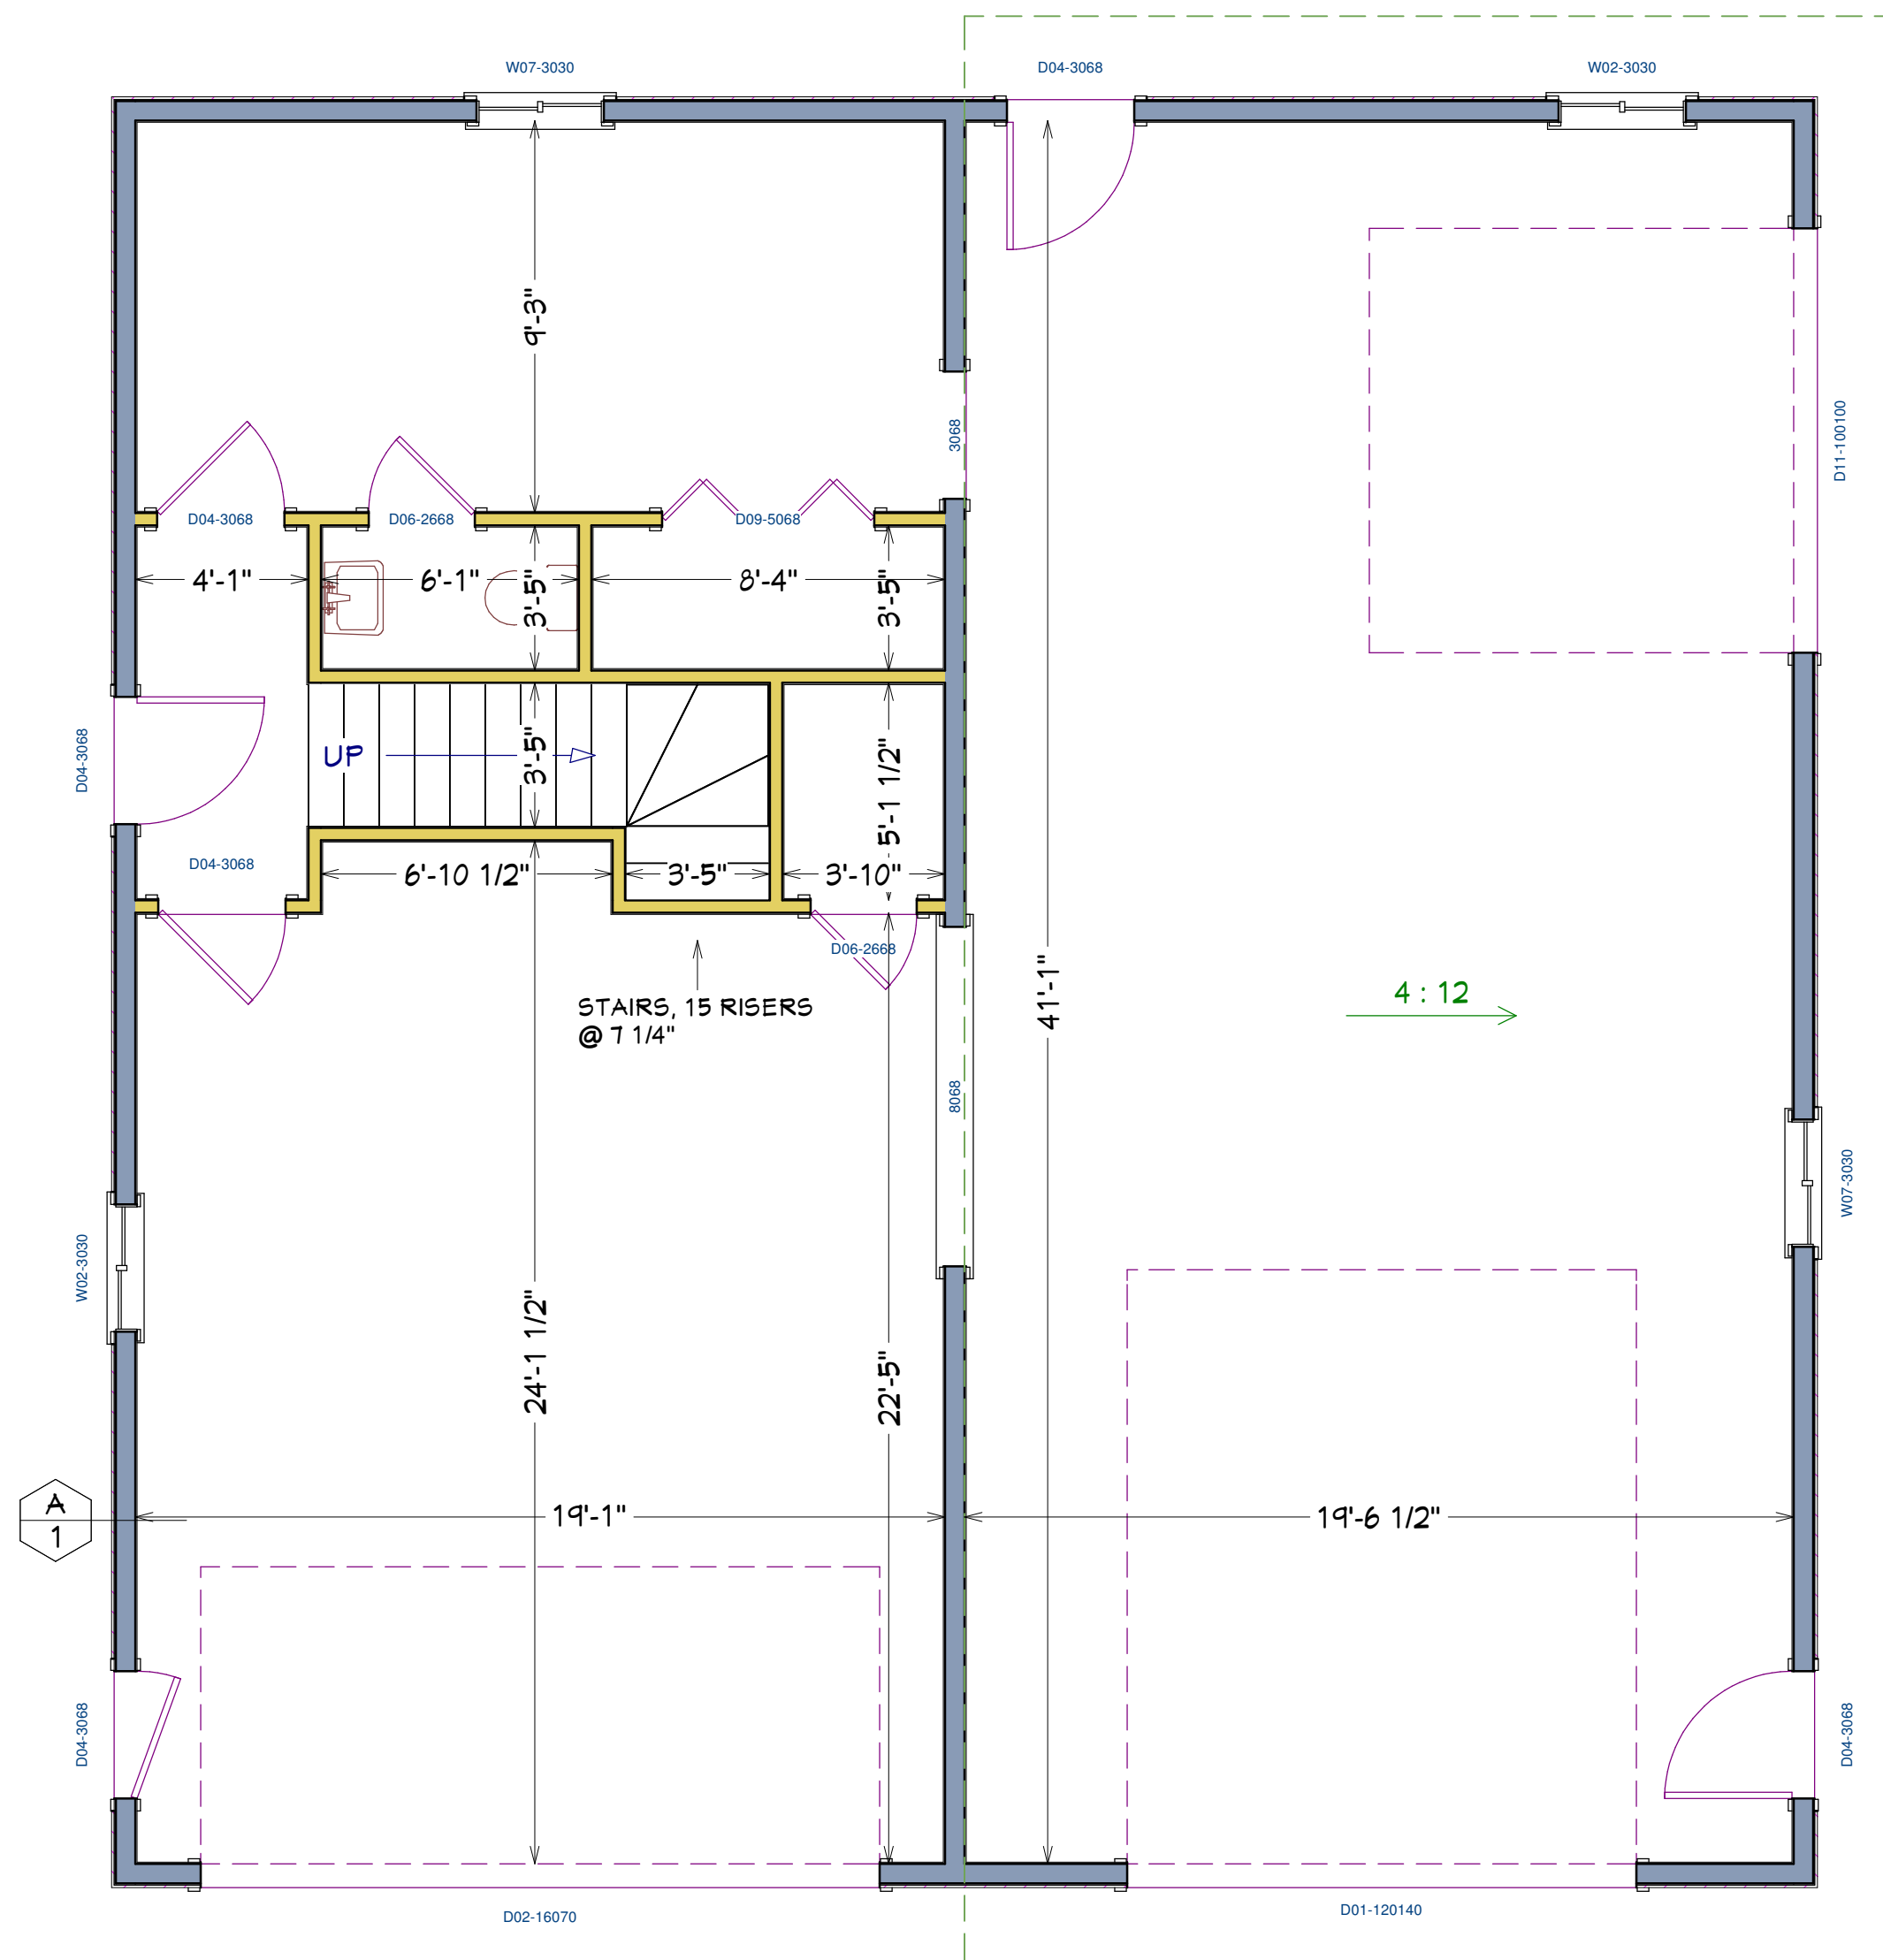

MAIN FLOOR PLAN
SCALE: 1/4" = 1'

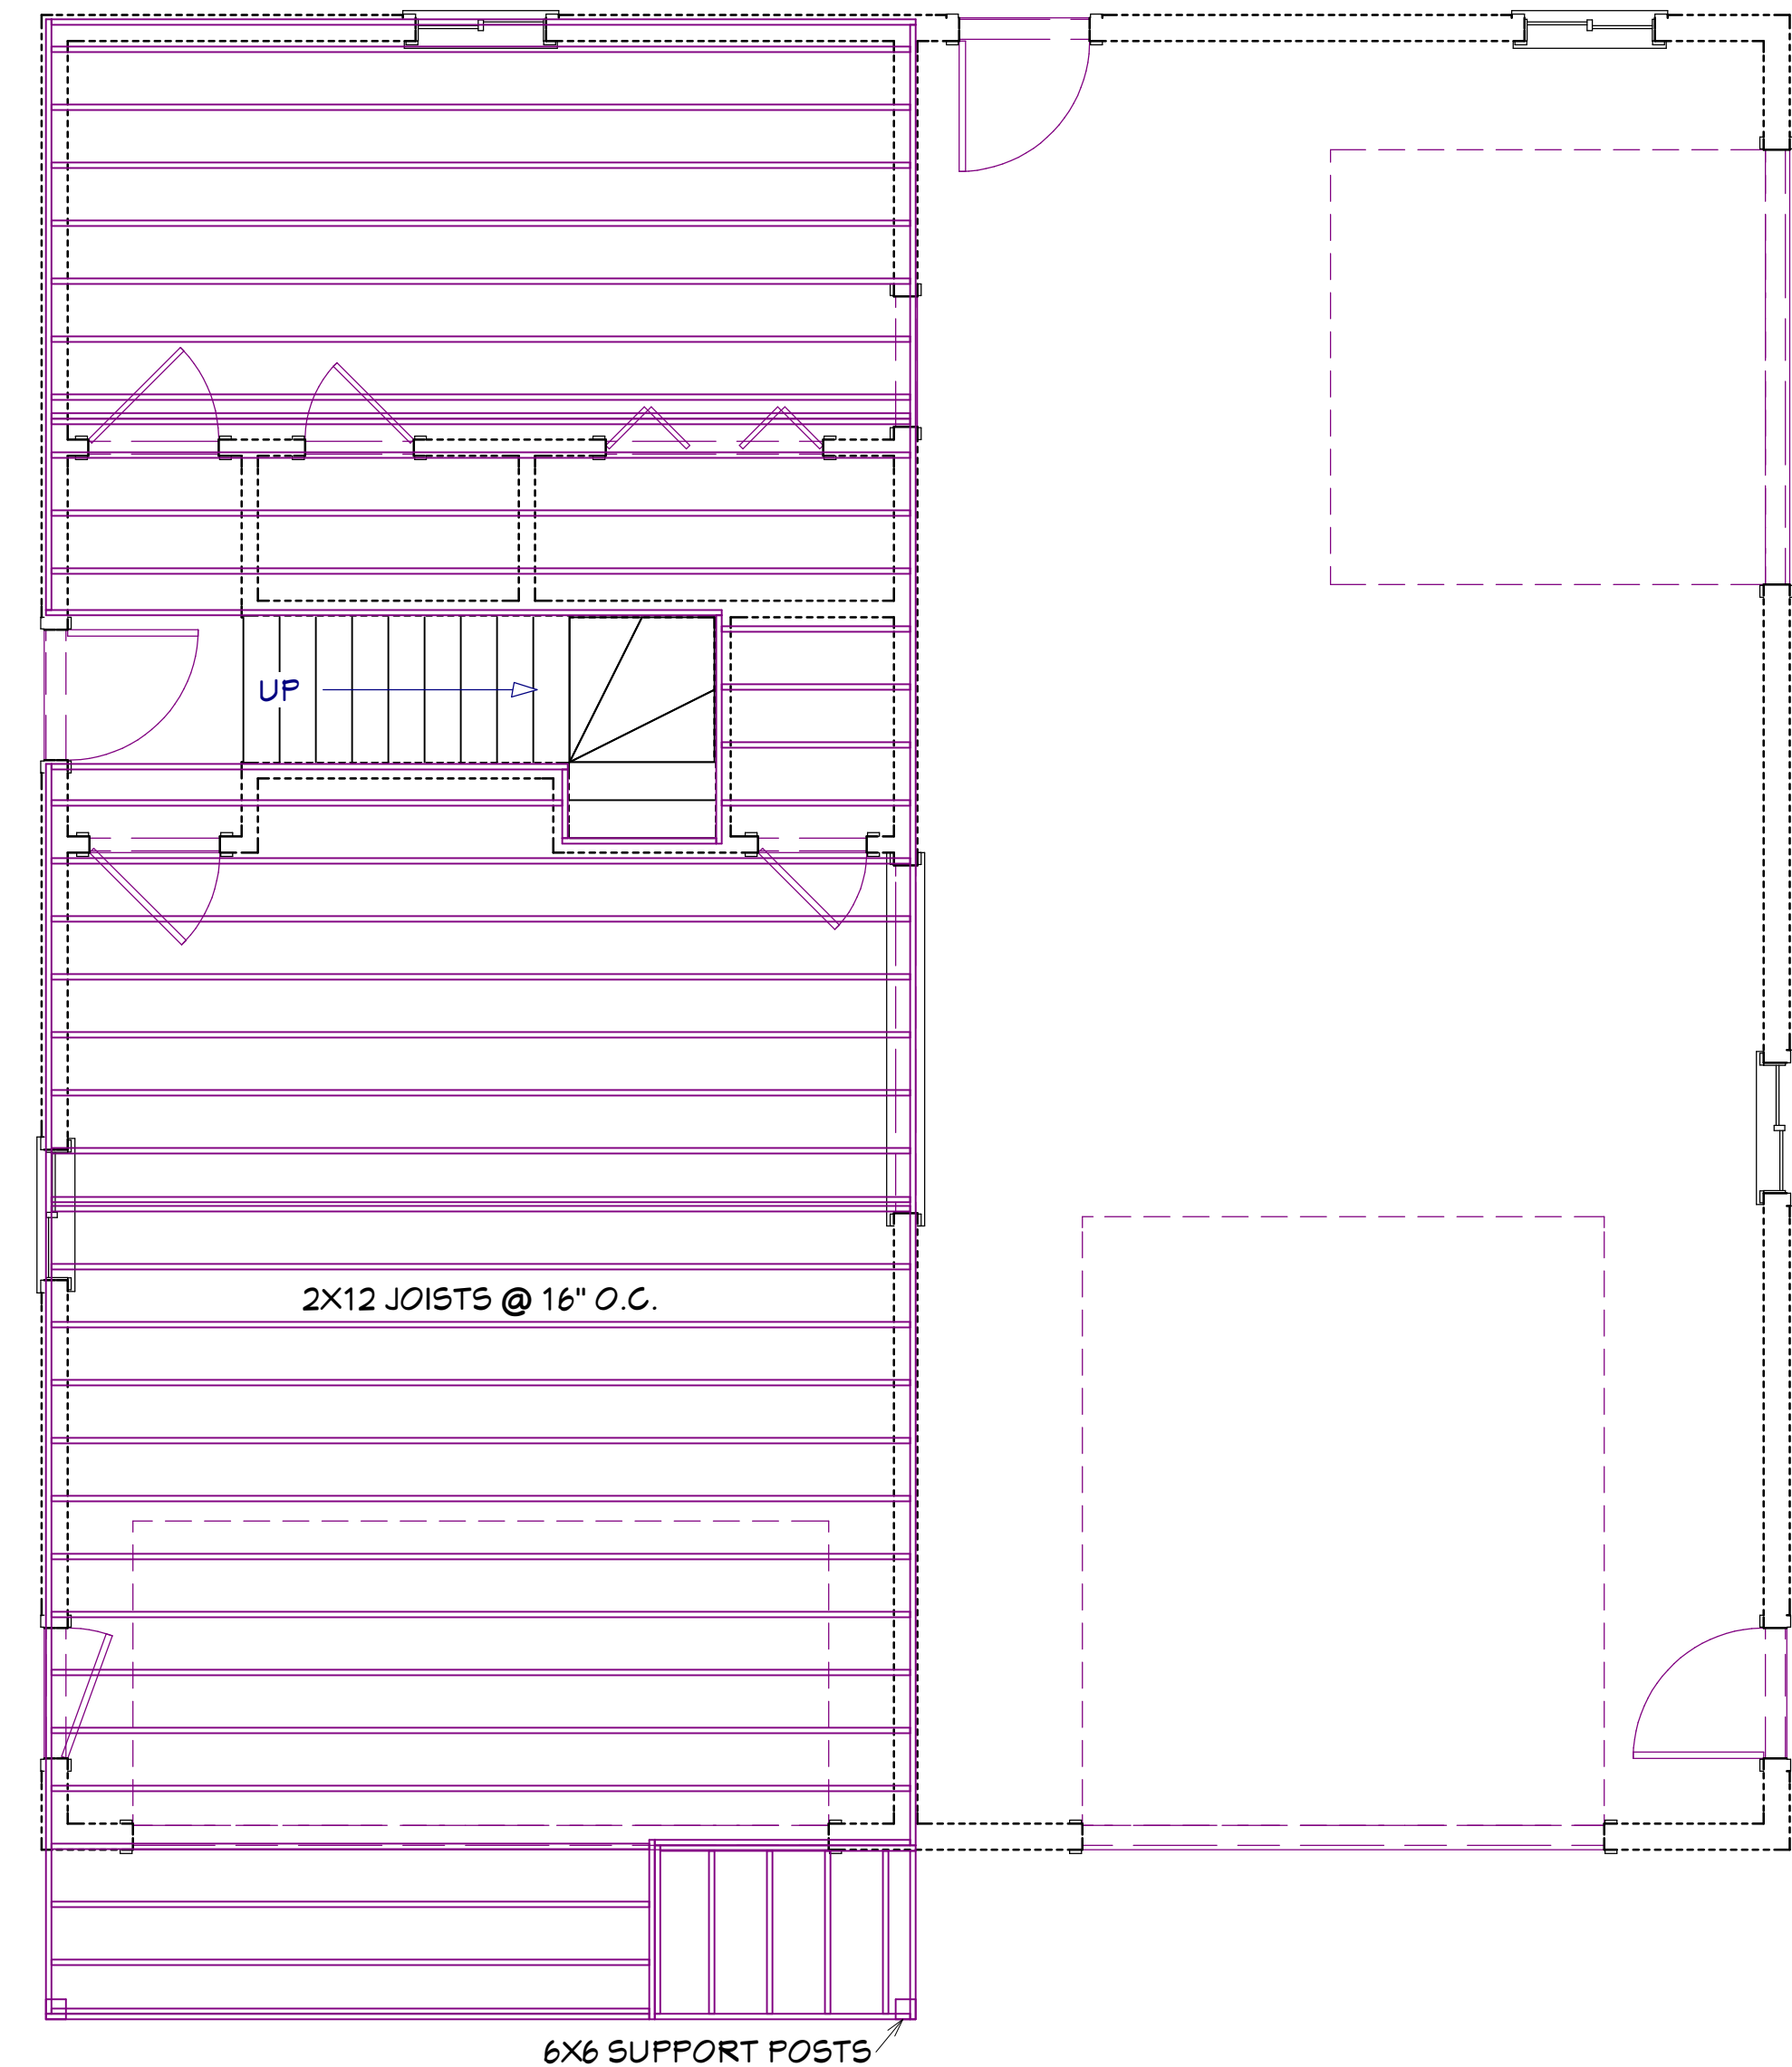


FLOOR FRAMING PLAN
SCALE: 1/4" = 1'


DOOR SCHEDULE					
NUMBER	LABEL	QTY	FLOOR	SIZE	COMMENTS
D01	D01-120140	1	1	120140	
D02	D02-16070	1	1	16070	
D03	D03-2460	1	2	2460	
D04	D04-3060	6	1	3060	
D05	D05-2660	1	2	2660	
D06	D06-2660	2	1	2660	
D07	D07-3060	3	2	3060	
D08	D08-4060	1	2	4060	
D09	D09-5060	1	1	5060	
D10	D10-5060	1	2	5060	
D11	D11-100100	1	1	100100	

WINDOW SCHEDULE						
NUMBER	LABEL	QTY	FLOOR	SIZE	DESCRIPTION	COMMENTS
W01	W01-6030	1	2	6030	LEFT SLIDING	
W02	W02-3030	2	1	3030	RIGHT SLIDING	
W03	W03-4060	4	2	4060	RIGHT SLIDING	
W04	W04-5060	1	2	5060	RIGHT SLIDING	
W05	W05-5060	1	2	5060	LEFT SLIDING	
W06	W06-4060	2	2	4060	LEFT SLIDING	
W07	W07-3030	2	1	3030	LEFT SLIDING	


40x42 House
#40X42H1C

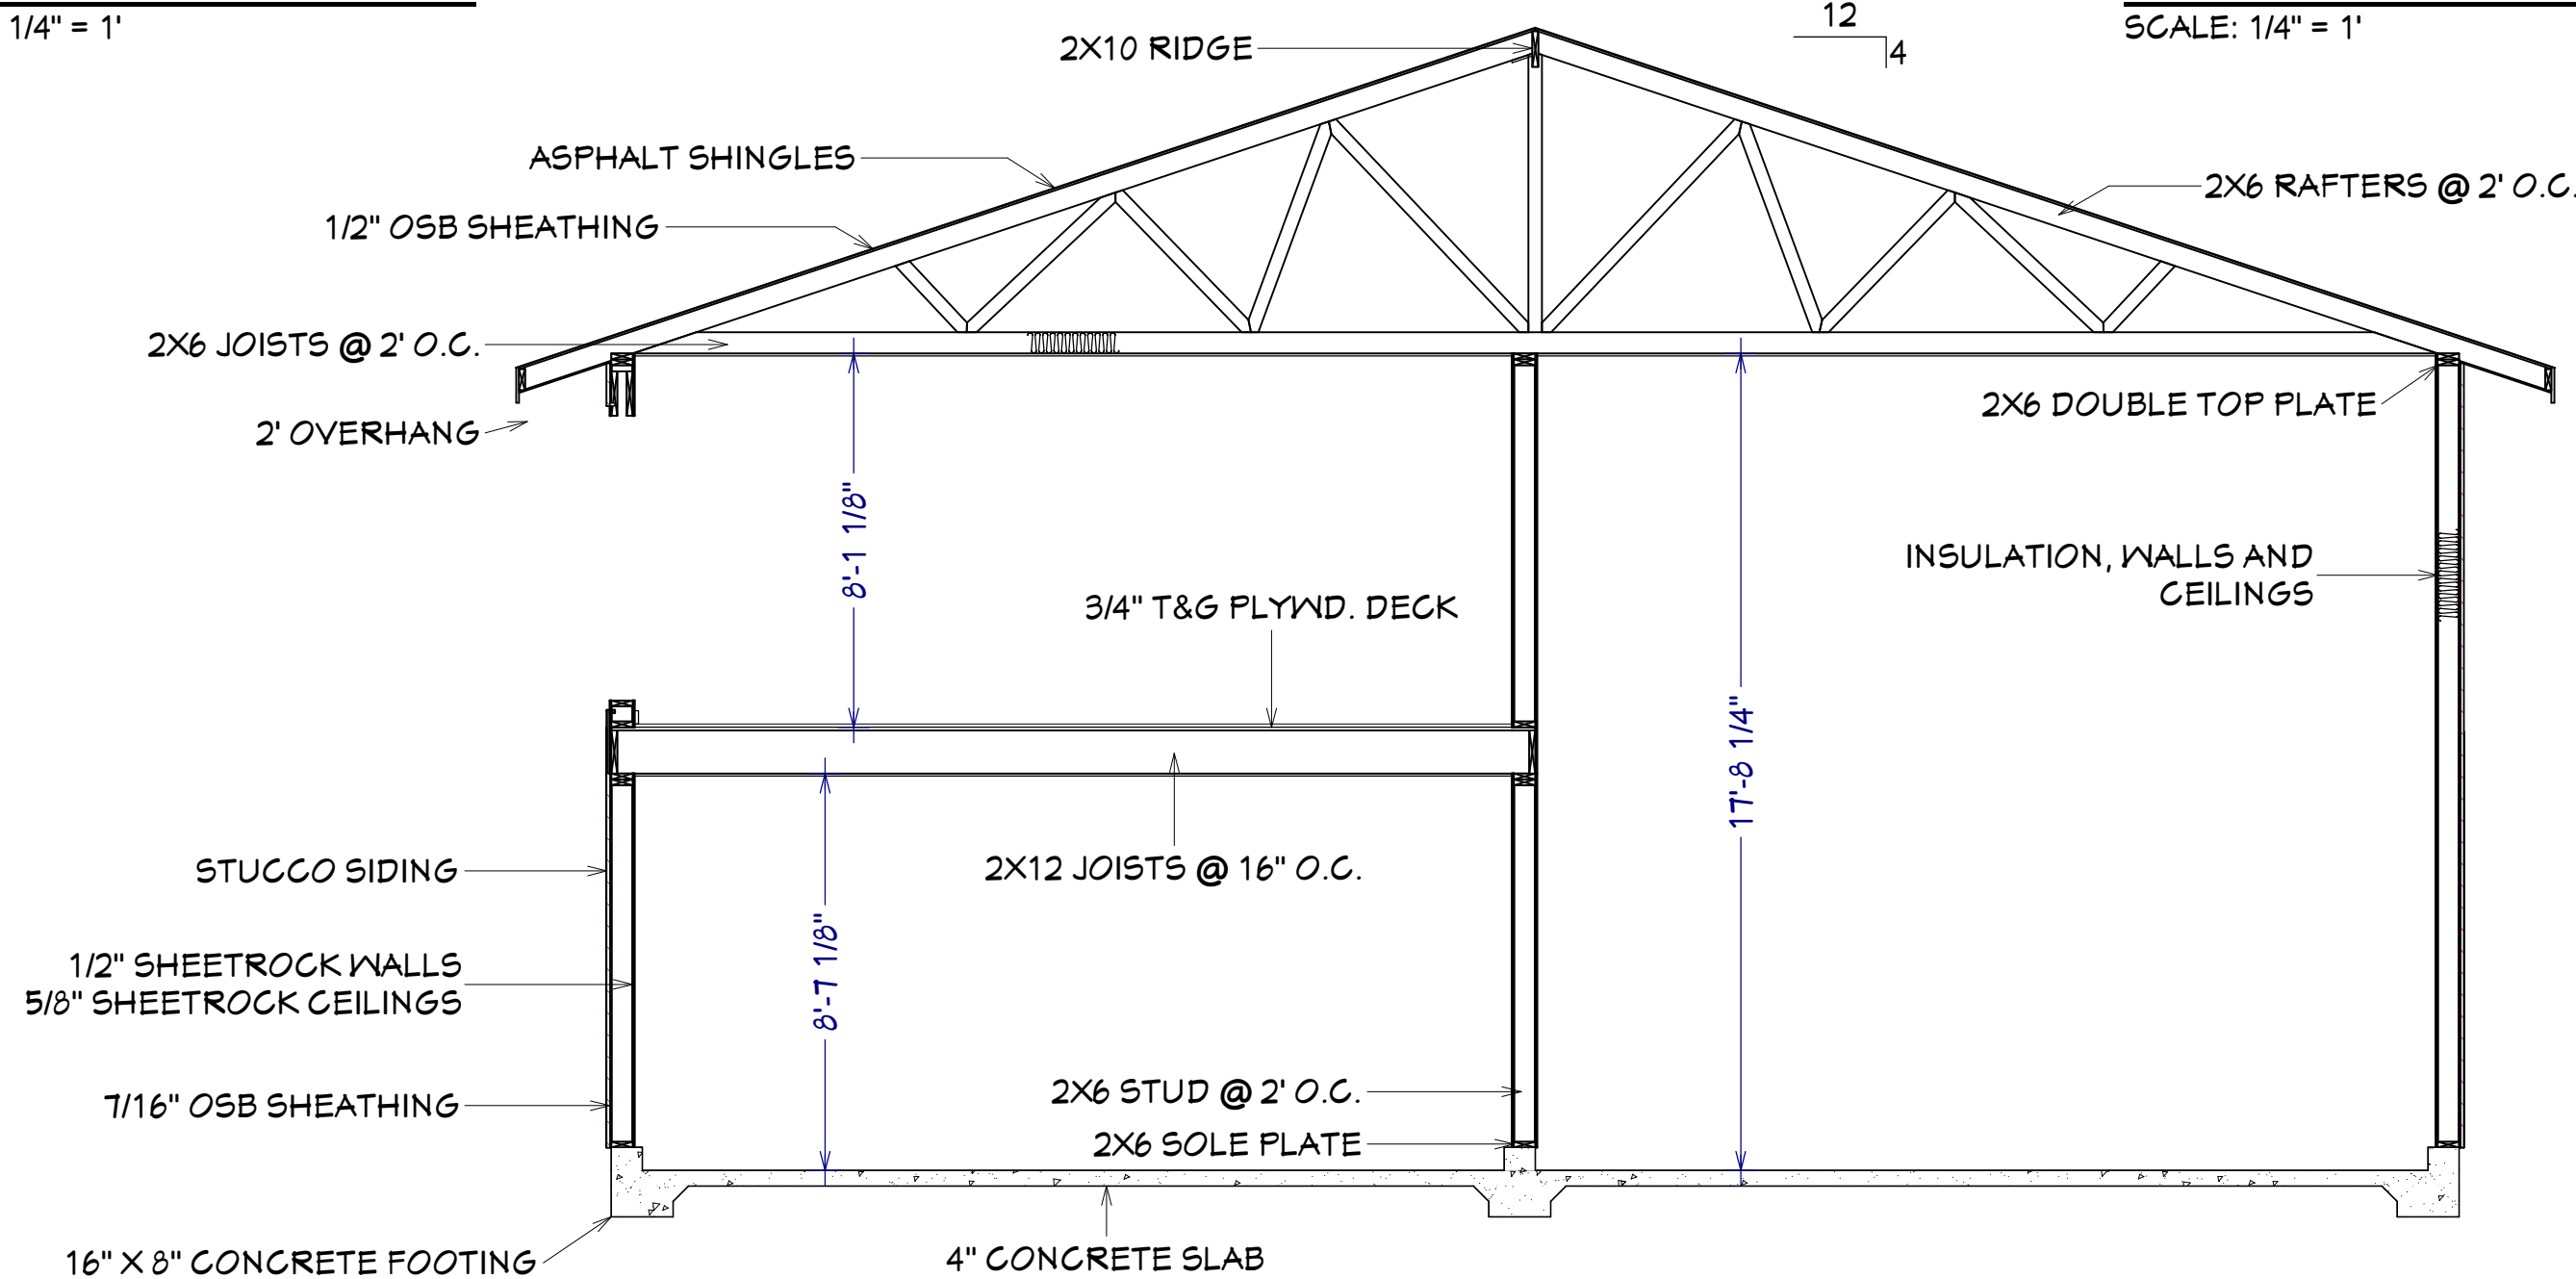


CROSS SECTION
SCALE: 1/4" = 1'

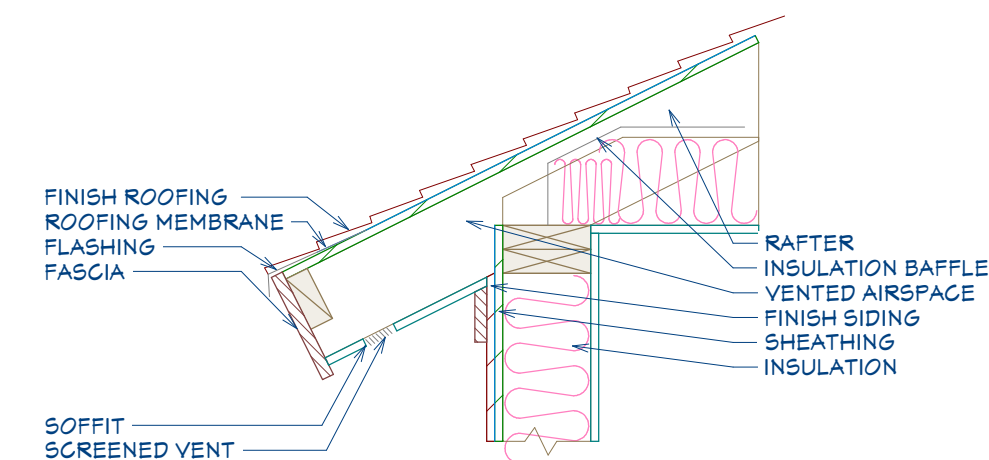


Boxed in Eave
SCALE: 1" = 1'

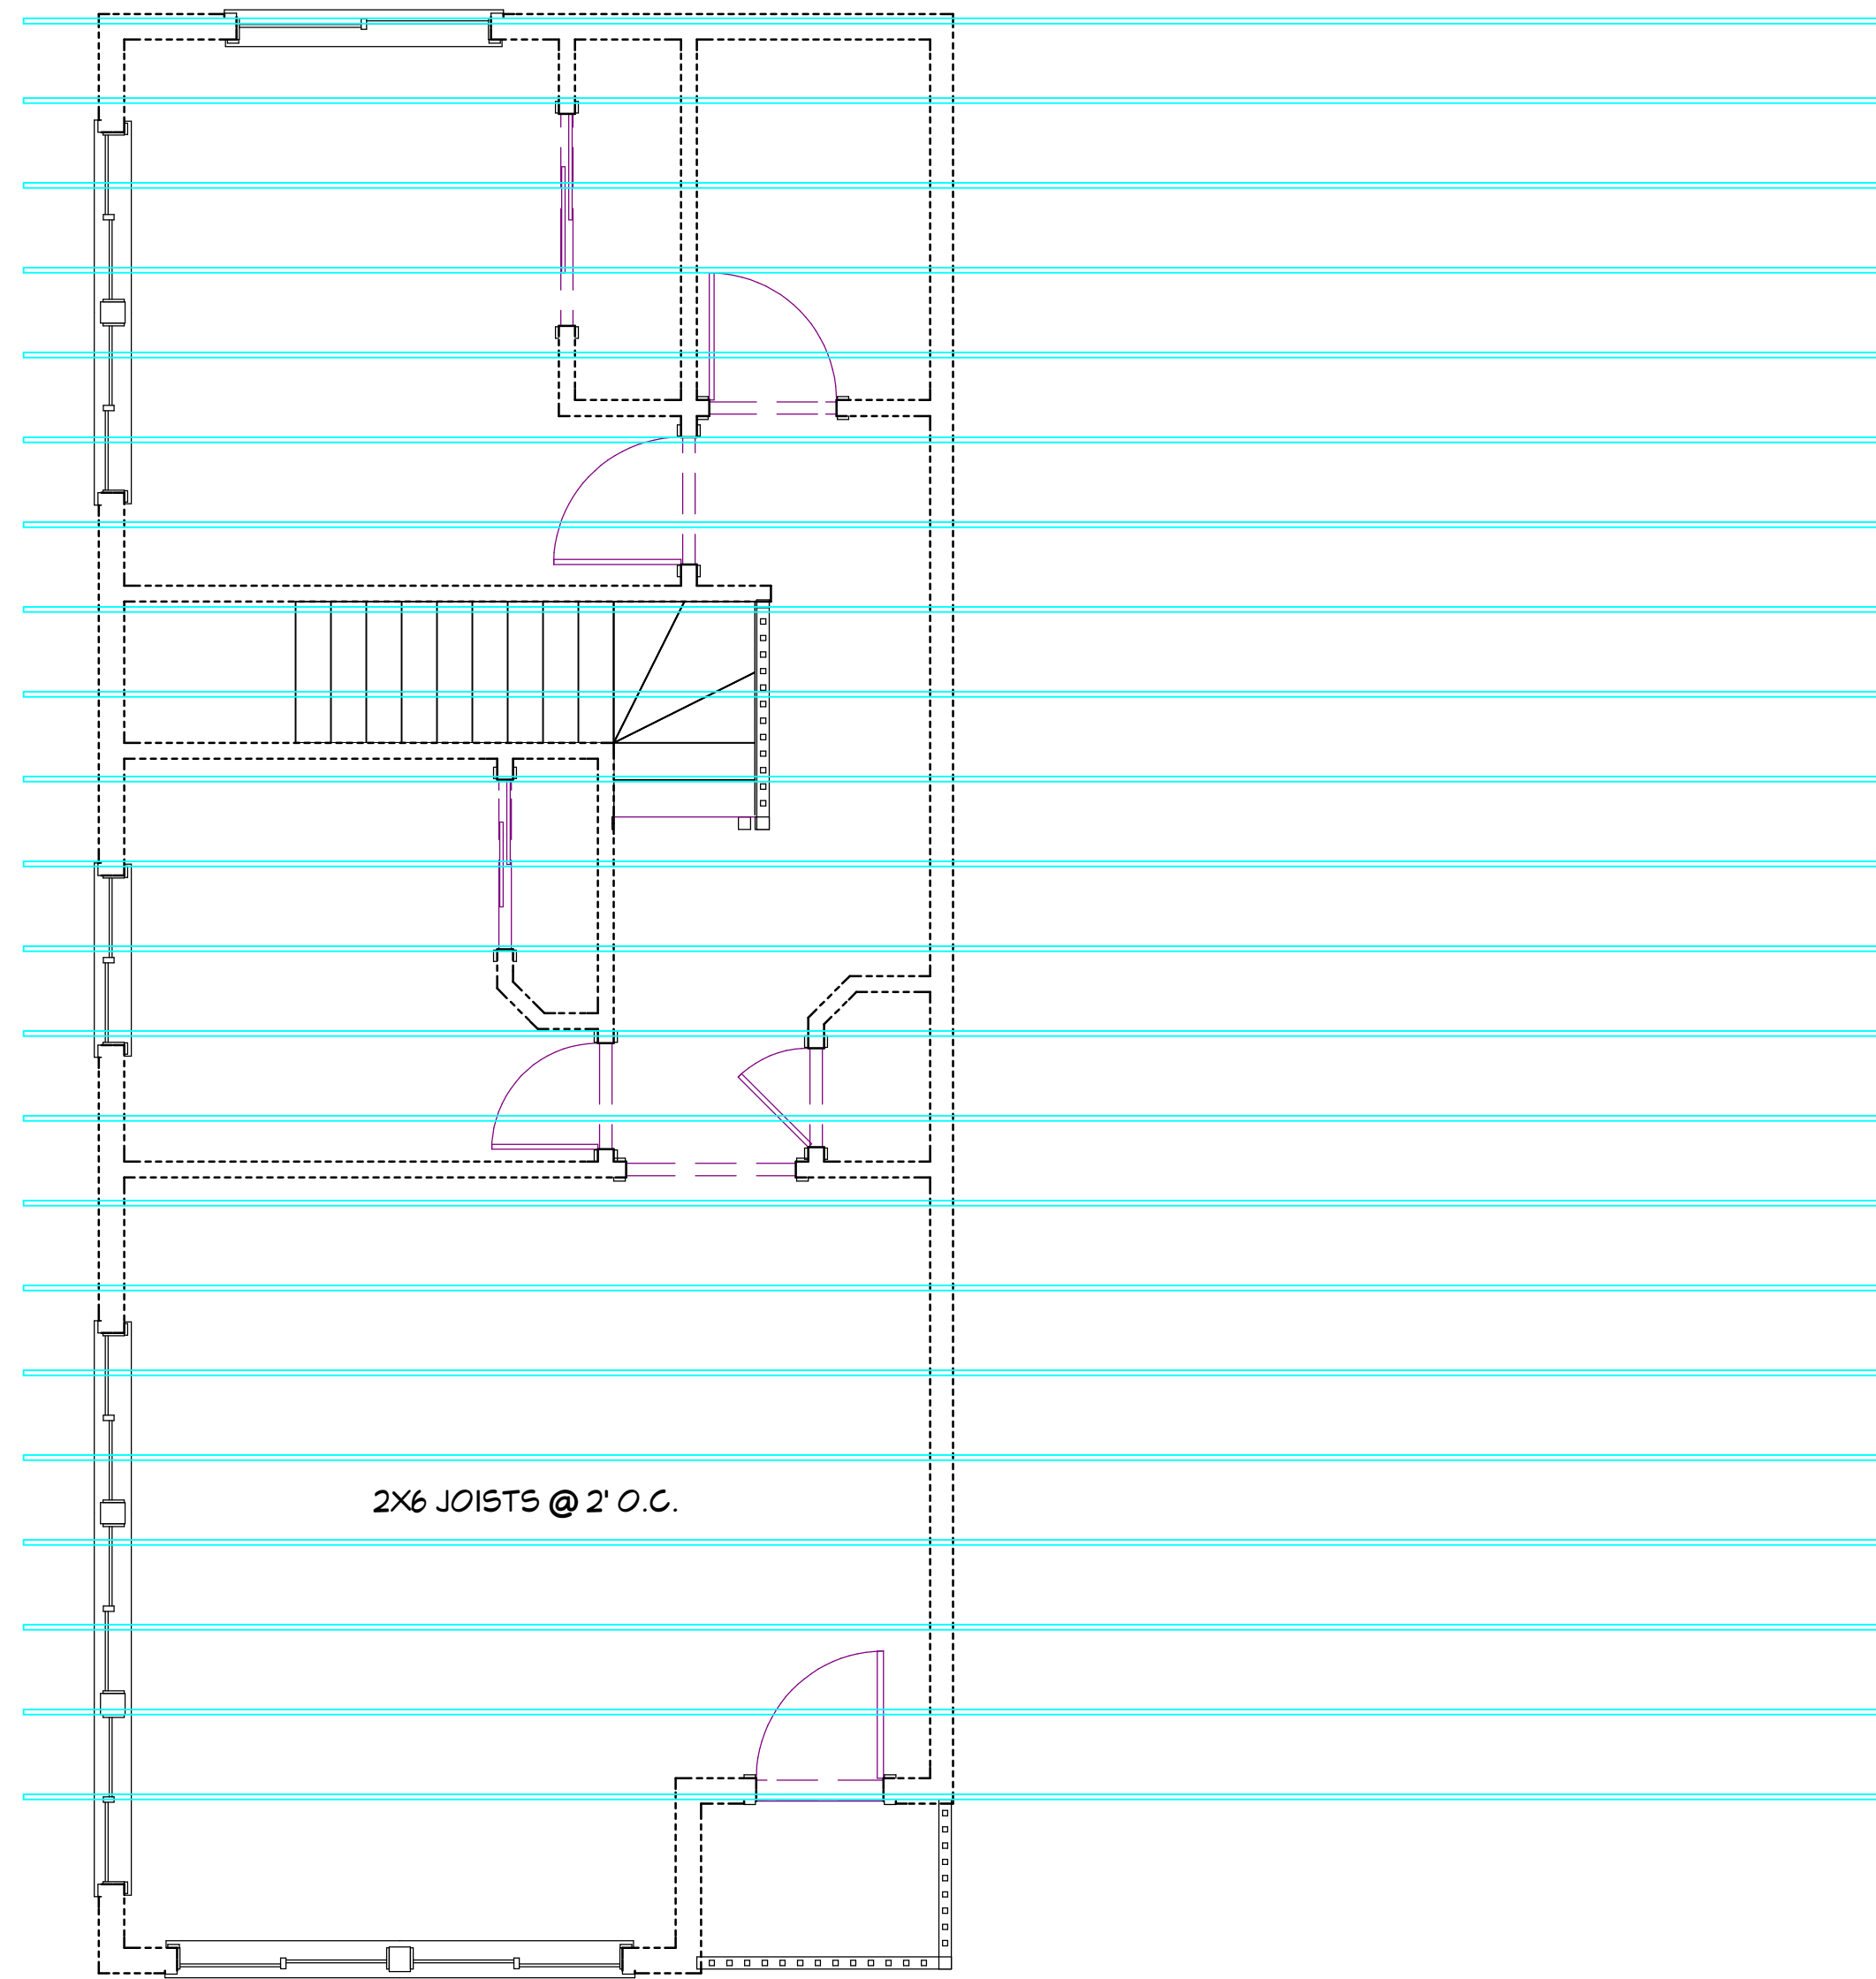


CEILING FRAMING PLAN
SCALE: 1/4" = 1'

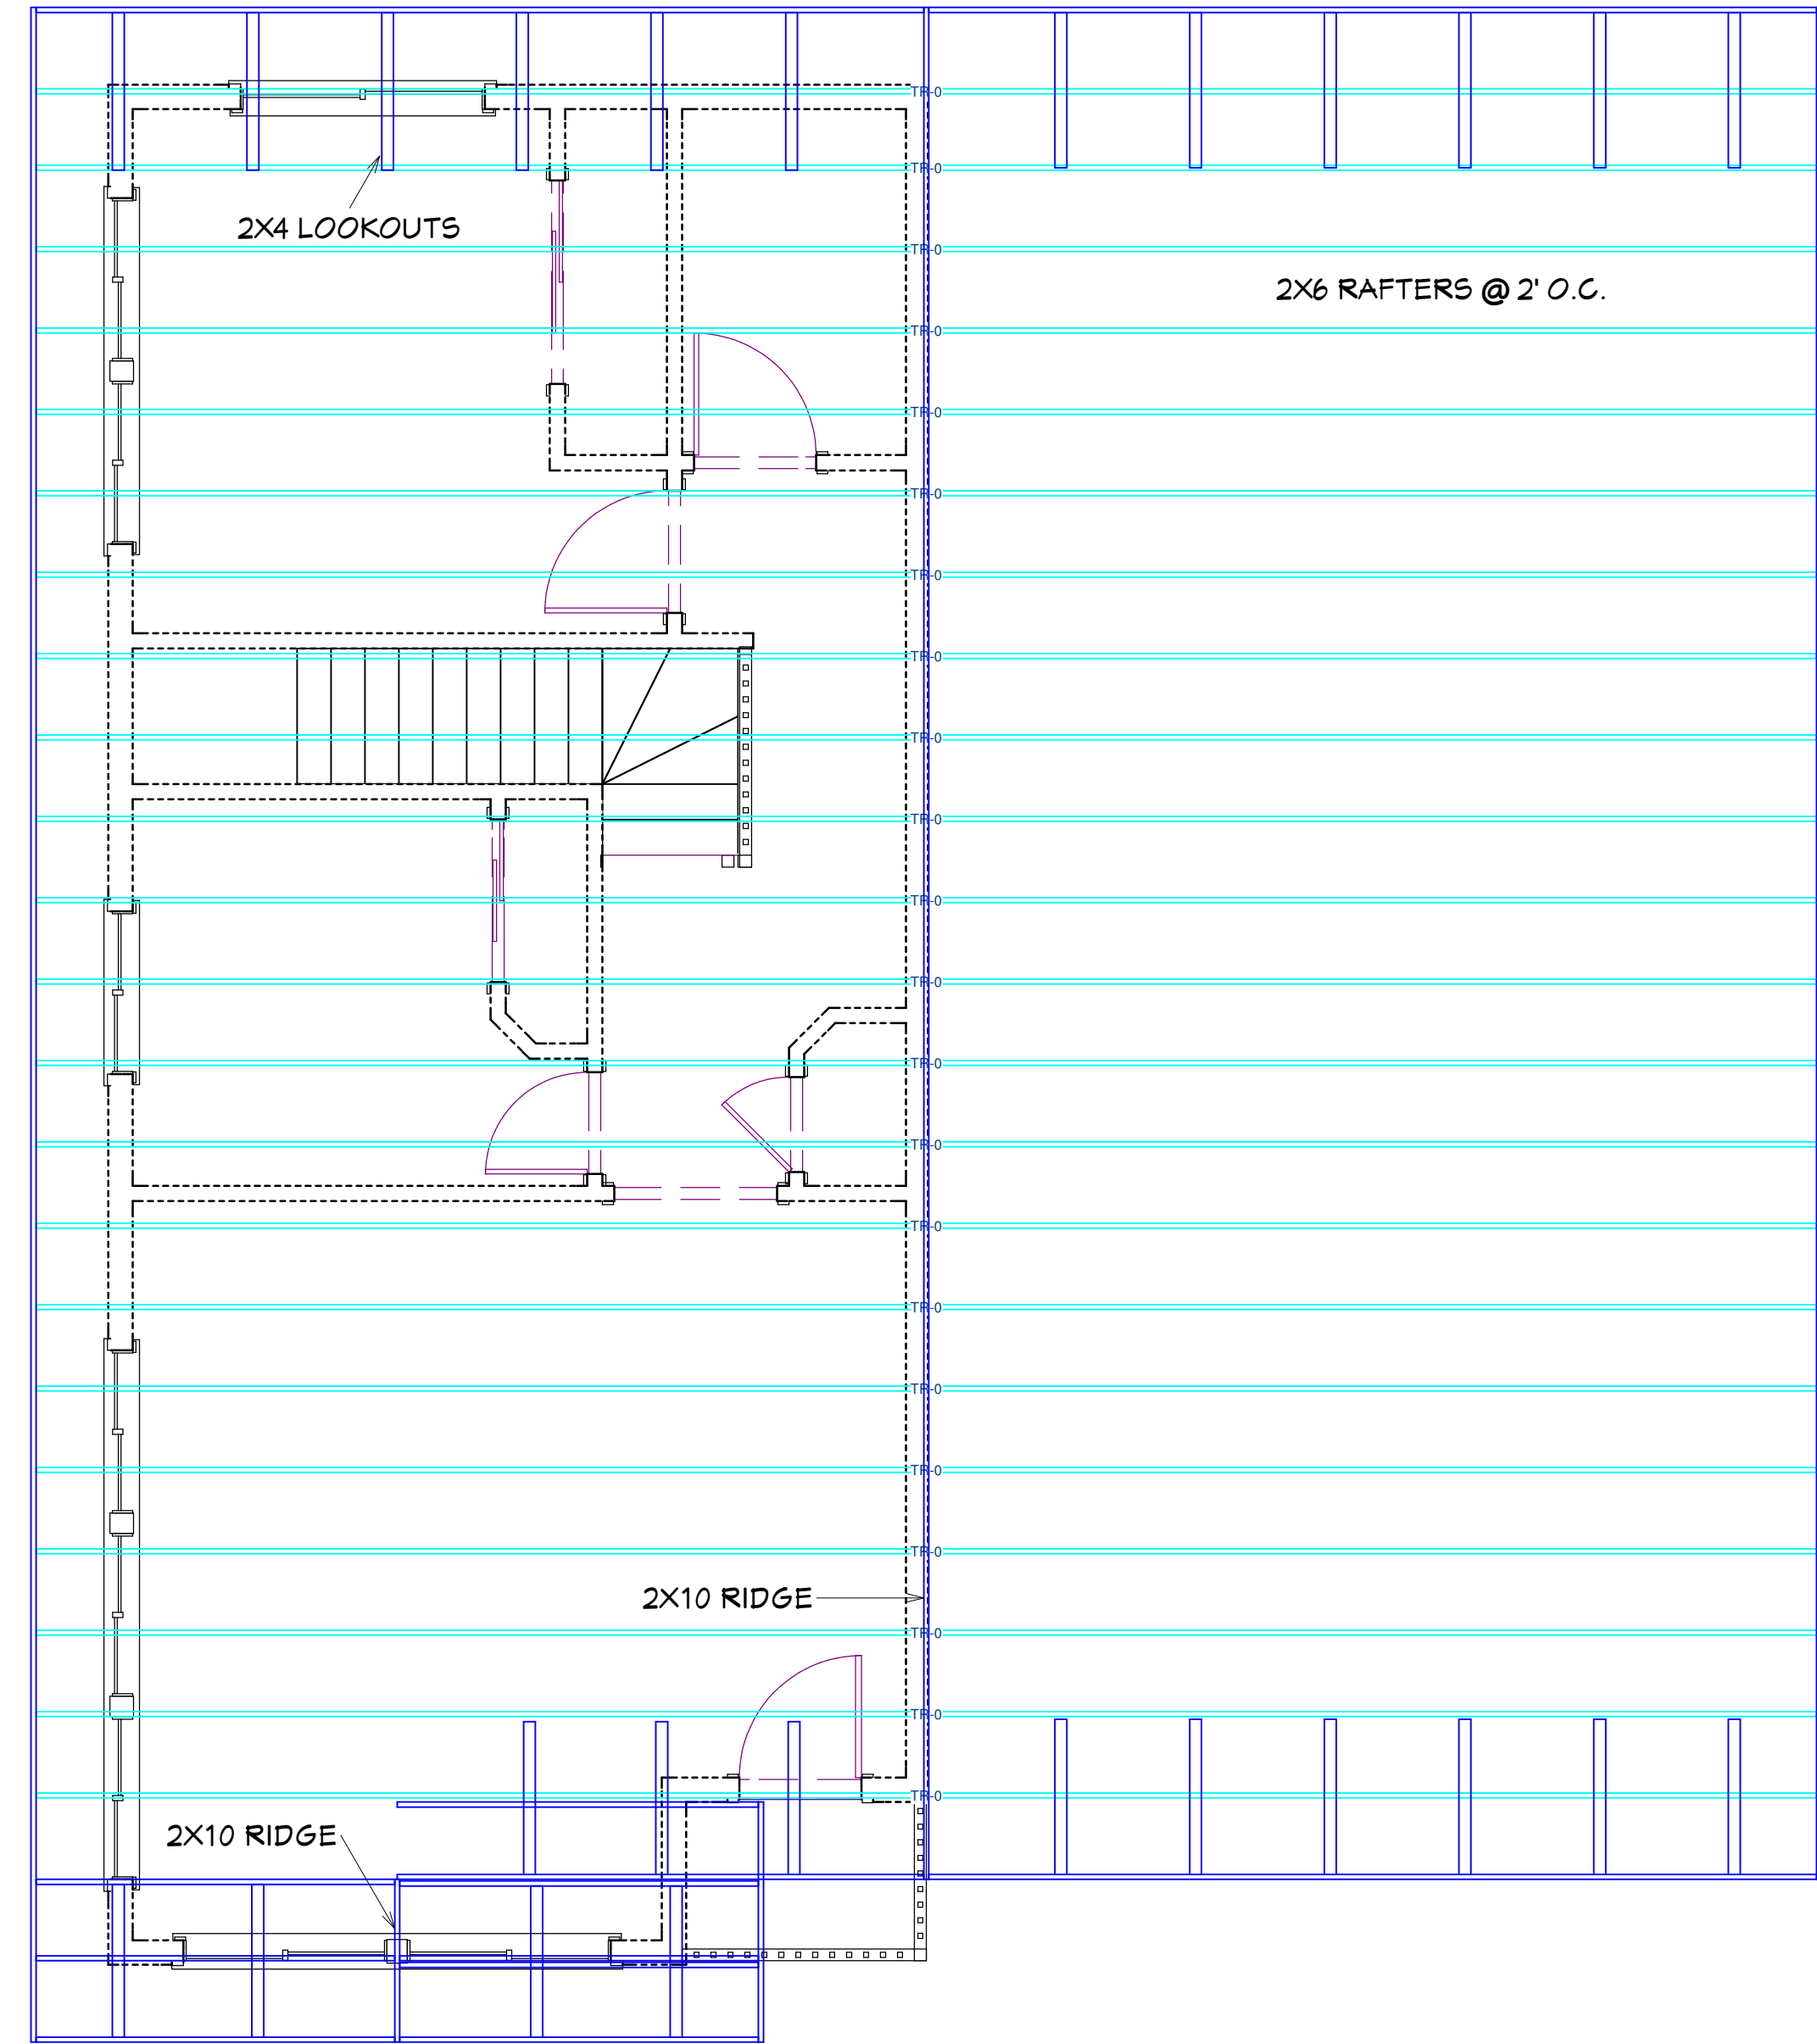

ROOF FRAMING PLAN
SCALE: 1/4" = 1'

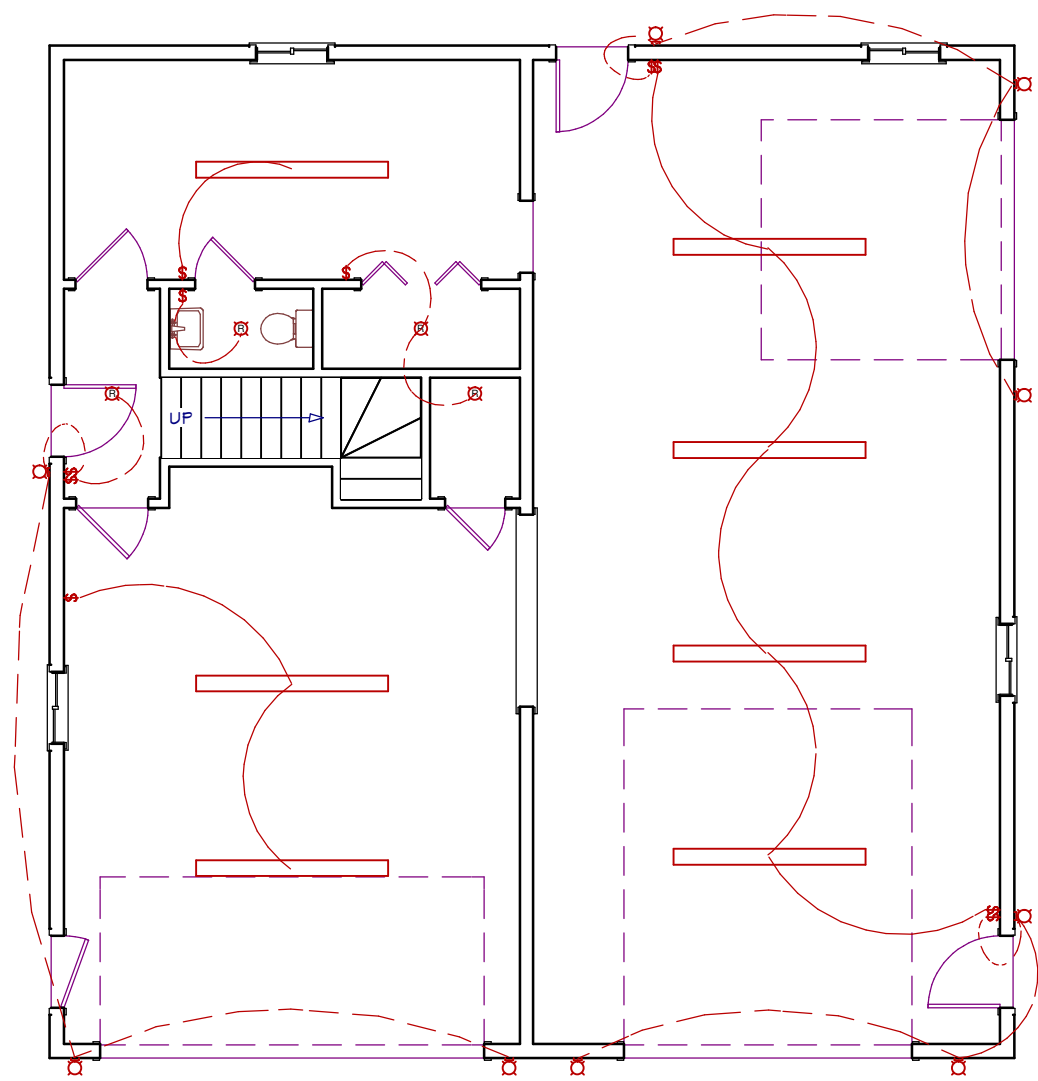


MAIN FLR. LIGHTING PLAN
SCALE: 1/8" = 1'

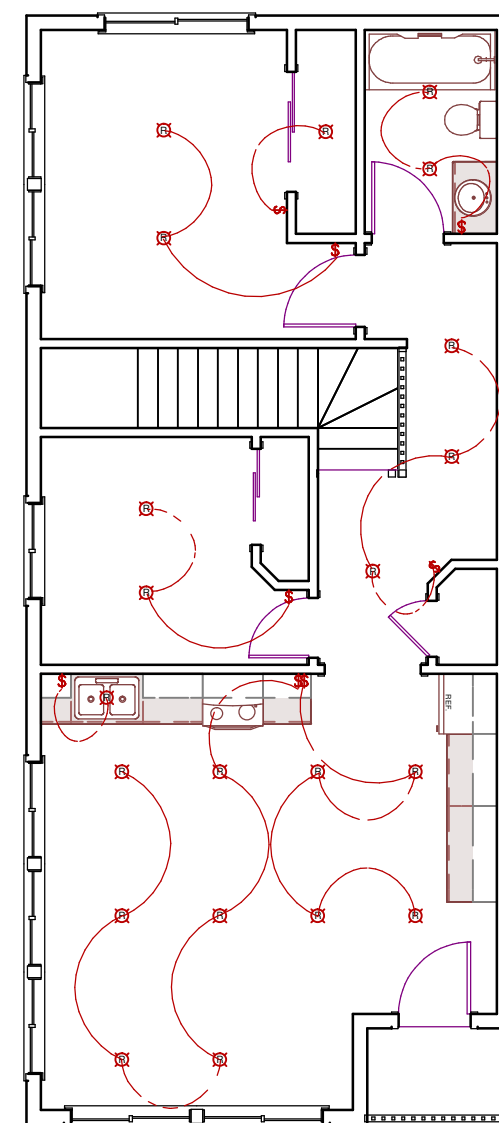

2ND FLR. LIGHTING PLAN
SCALE: 1/8" = 1'

 ALL WIRING TO BE INSTALLED AS PER ACTUAL JOBSITE CONDITIONS, ELECTRICAL CODE AND HOME OWNER OR INTERIOR LIGHTING CONSULTANT. SHOWN IS SUGGESTED PLACEMENT OF LIGHTING AND SWITCHING AND MUST BE APPROVED BY HOMEOWNER PRIOR TO WORK.

 RECESSED DOWN LIGHT
 PORCH LANTERN
 96" FLUORESCENT LIGHT

40x42 House
#40X42H1C

IDEAS

40x42 House
#40X42H1C

